


CONSTRUCTION PLANS

- for -

WASTEWATER TREATMENT FACILITY

Branford, CT

FEBRUARY 1999

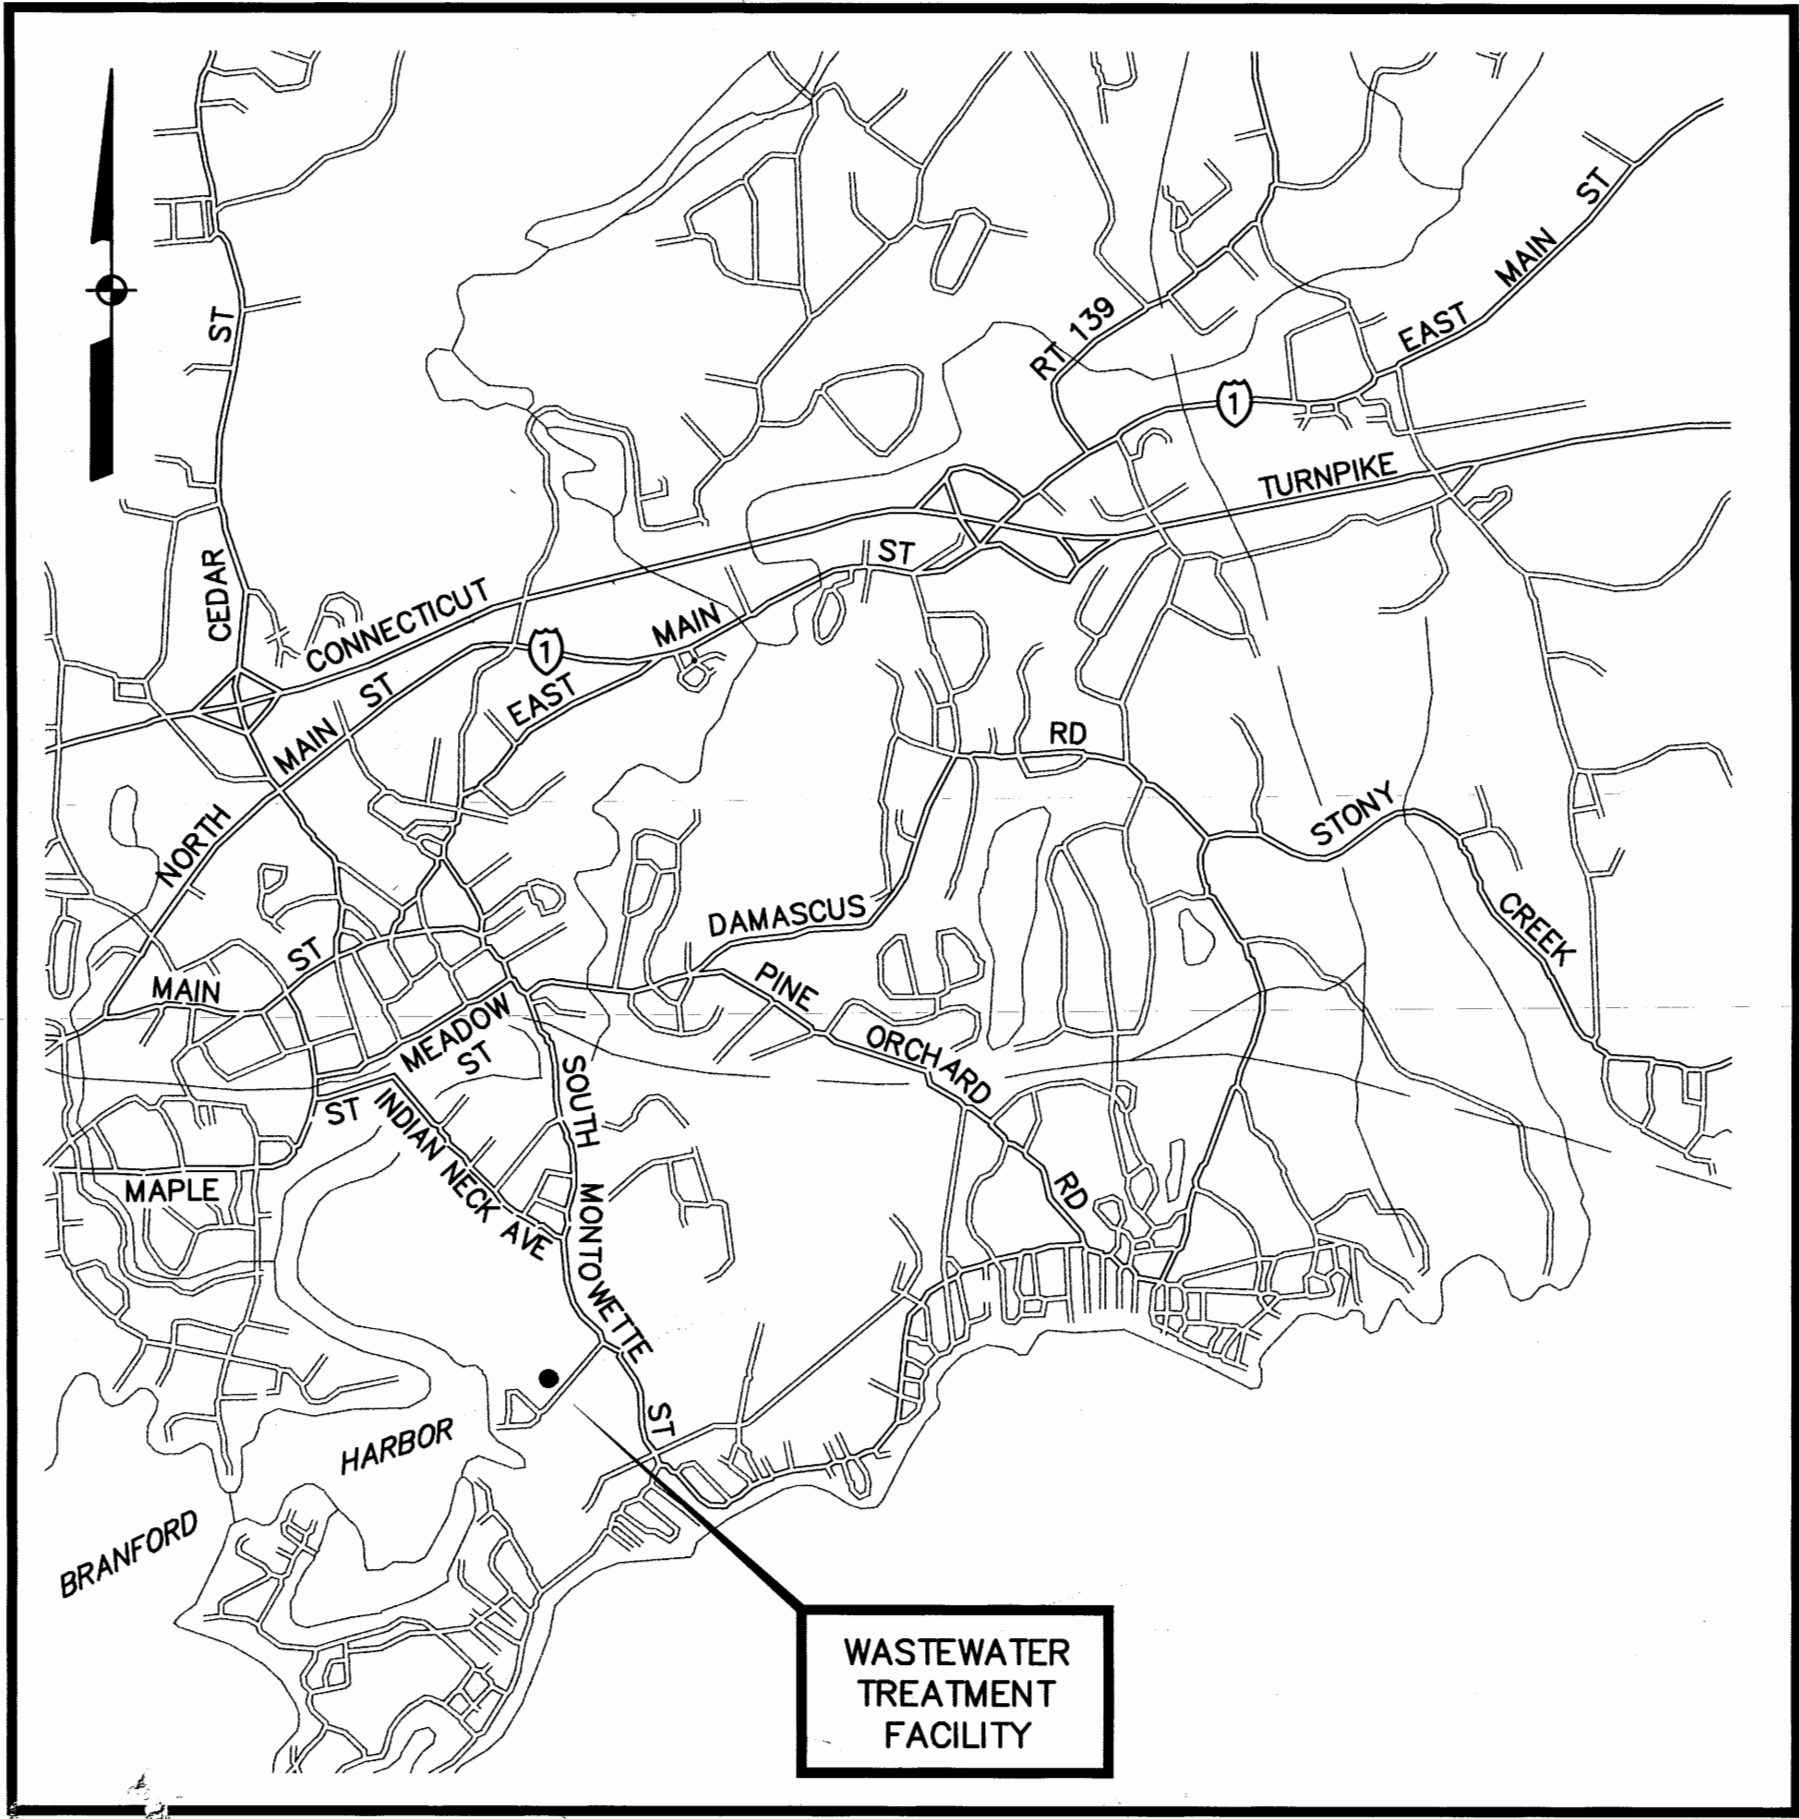

LOCUS

GENERAL NOTES

LOCATIONS OF ALL UTILITIES AND SUB-SURFACE STRUCTURES ARE FROM SURVEY AND RECORDS OF TOWN, CORPORATIONS, ETC., AND ARE CONSIDERED APPROXIMATE BOTH AS TO SIZE AND LOCATION AND ARE INDICATED ON THESE DRAWINGS TO GIVE BIDDERS A GENERAL IDEA OF EXISTING CONDITIONS TO BE INVESTIGATED BY THE BIDDER. IT IS UNDERSTOOD AND AGREED THAT EACH BIDDER WILL NOT RELY UPON THESE DRAWINGS FOR SUCH INFORMATION, BUT THAT EACH BIDDER SHALL MAKE EXAMINATIONS IN THE FIELD BY VARIOUS AVAILABLE METHODS AND SHALL OBTAIN INFORMATION FROM UTILITY CORPORATIONS AND INDIVIDUALS AS TO THE LOCATION OF ALL SUB-SURFACE STRUCTURES.

ALL ELEVATIONS REFER TO NATIONAL GEODETIC VERTICAL DATUM OF 1929.



655 Winding Brook Drive Glastonbury, Ct.

ABBREVIATIONS FOR PIPE TYPES

E A R T H T E C H



855 Winding Brook Drive Sheltonbury, Ct. 06033-4337 (860) 857-1900

[illegible]

BRANFORD, CT
WASTEWATER TREATMENT FACILITY
ABBREVIATIONS AND SYMBOLS

DESIGNED BY DGS	DWG SCALE NONE
DRAWN BY NThomson	CONTRACT NO 31
CHECKED BY KAB	DATE FEB. 1999

M-1


SHEET 74 OF 169

NO	REVISIONS	BY	JPR	11/02	DATE
1	REVISED TO RECORD PLAN				

[illegible]

BRANFORD, CT
WASTEWATER TREATMENT FACILITY
SECONDARY PROCESS BUILDING – FIRST FLOOR PLAN

DESIGNED BY D.G.S.	DWG SCALE AS NOTED
DRAWN BY JZANIBONI	CONTRACT NO. 31
CHECKED BY K.A.B.	DATE FEB. 1999




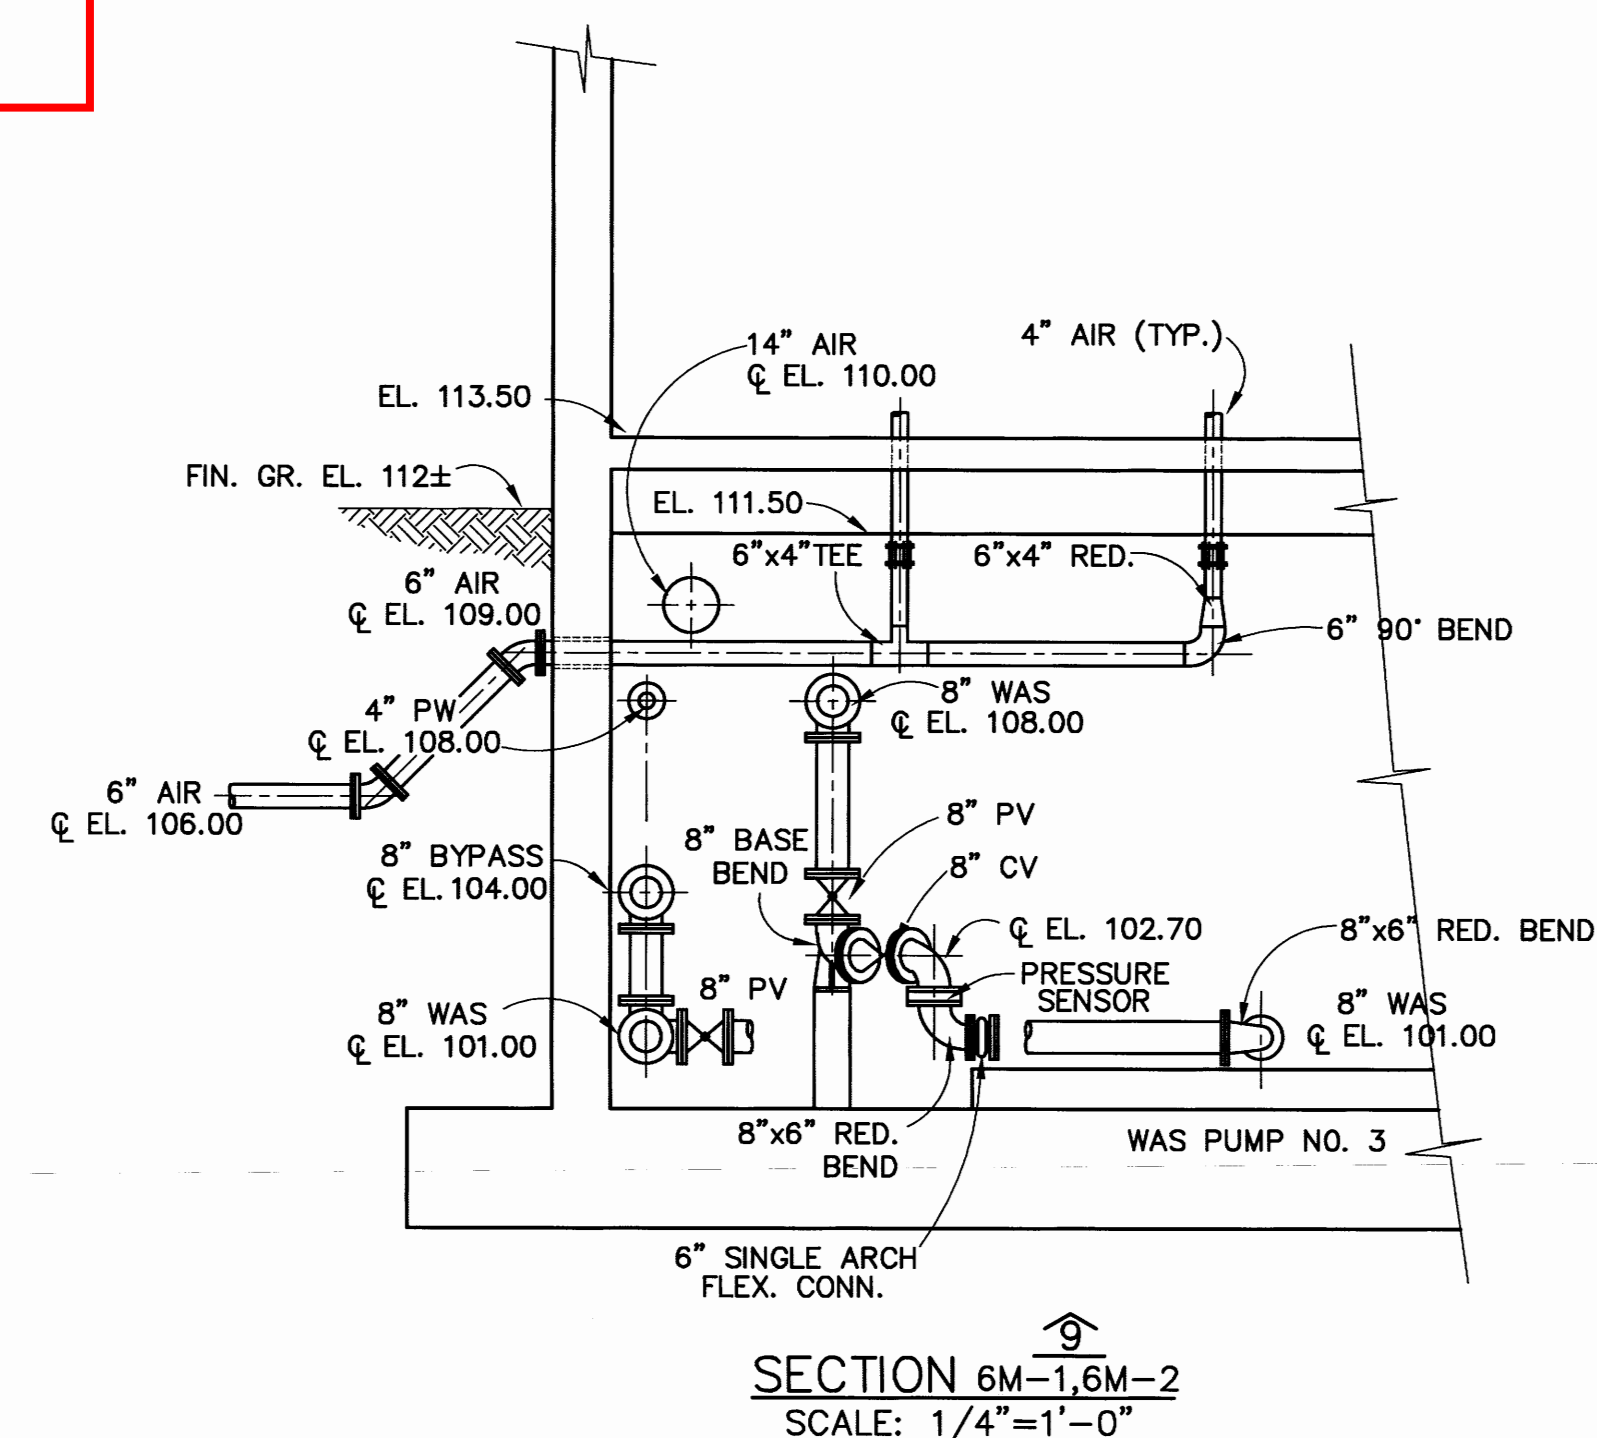


FIRST FLOOR PLAN – SECONDARY PROCESS BUILDING
SCALE: 1/4"=1'-0"

NOTE: BLOWERS NOT SHOWN


RECORD PLAN

U:\work\24603\24603.dwg AS BUILT\MECA\Bldg.dwg, Model, 01/27/2024, 01:58:47 PM, acorn.martin, 1 of 8

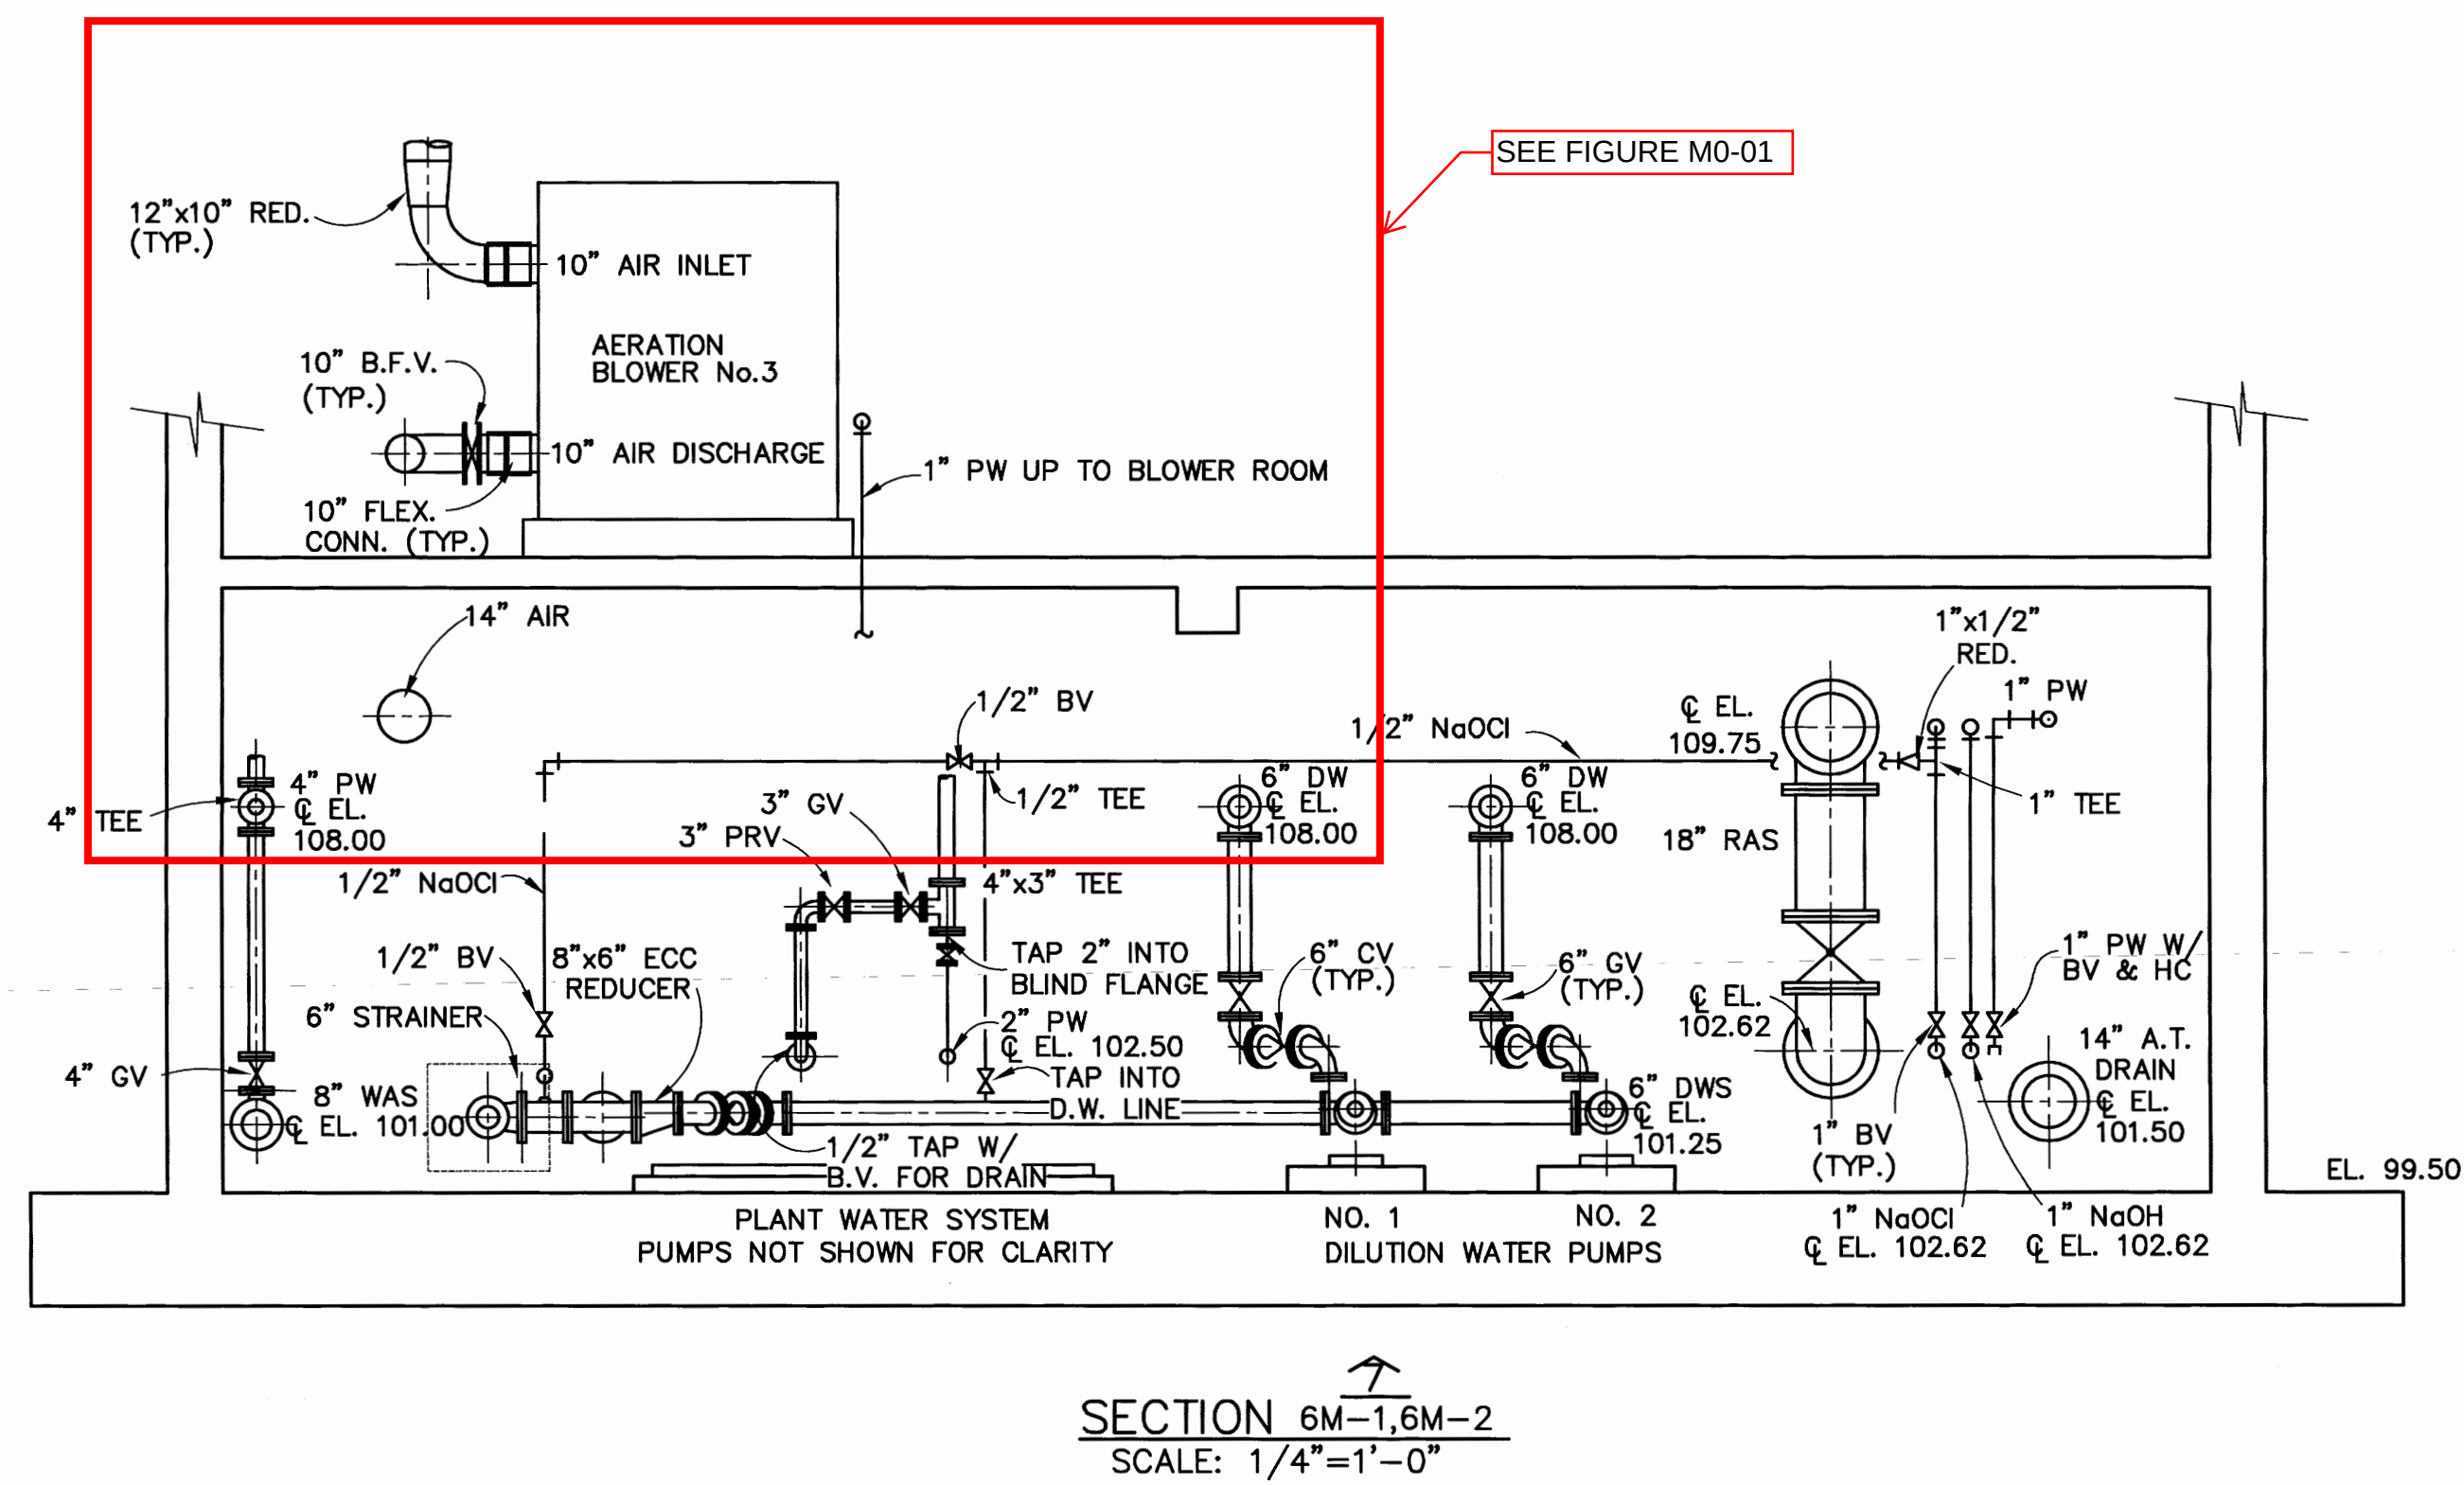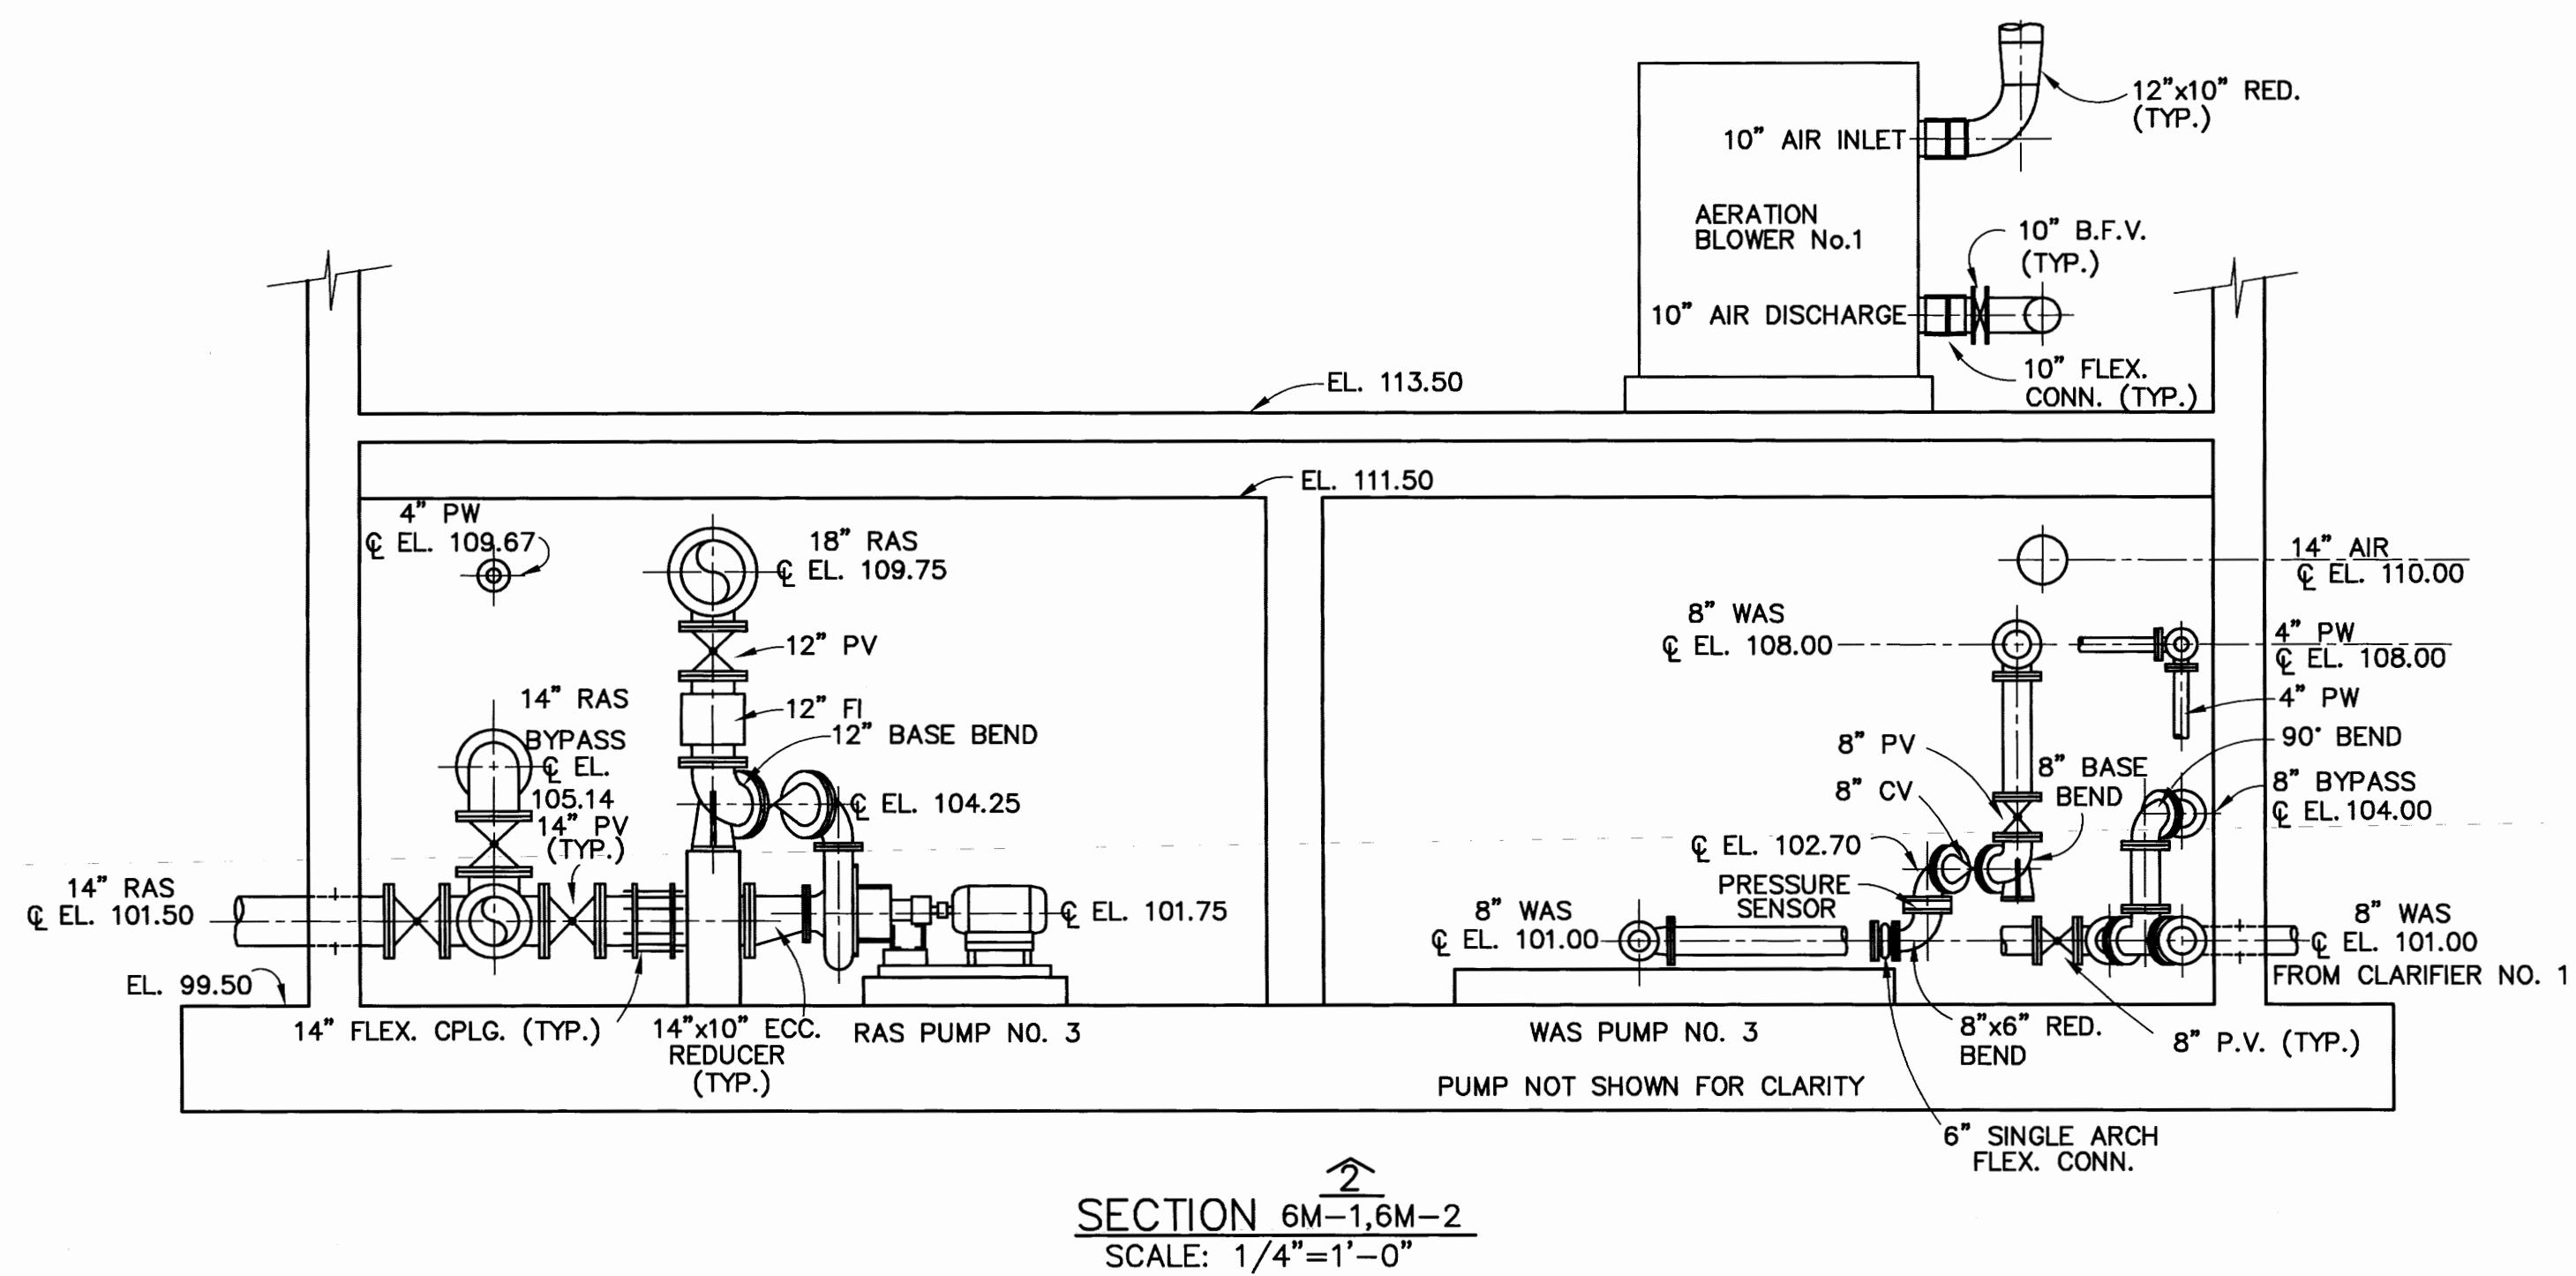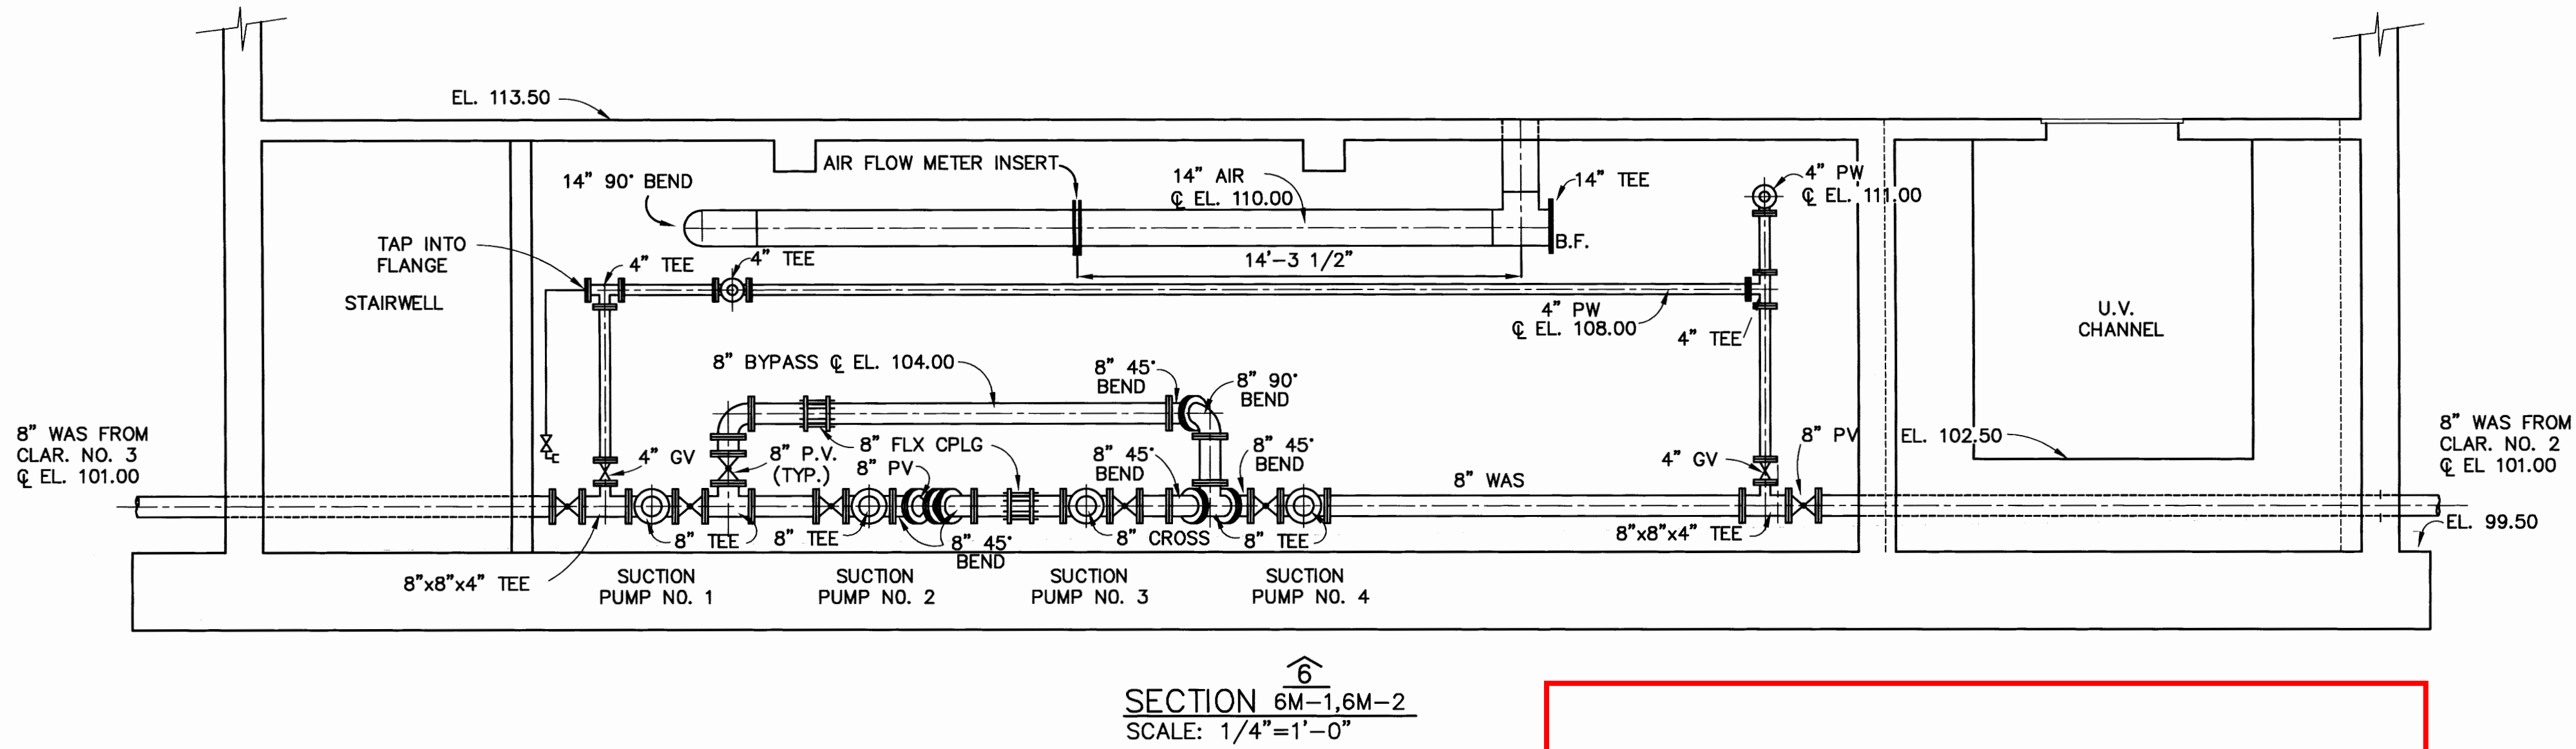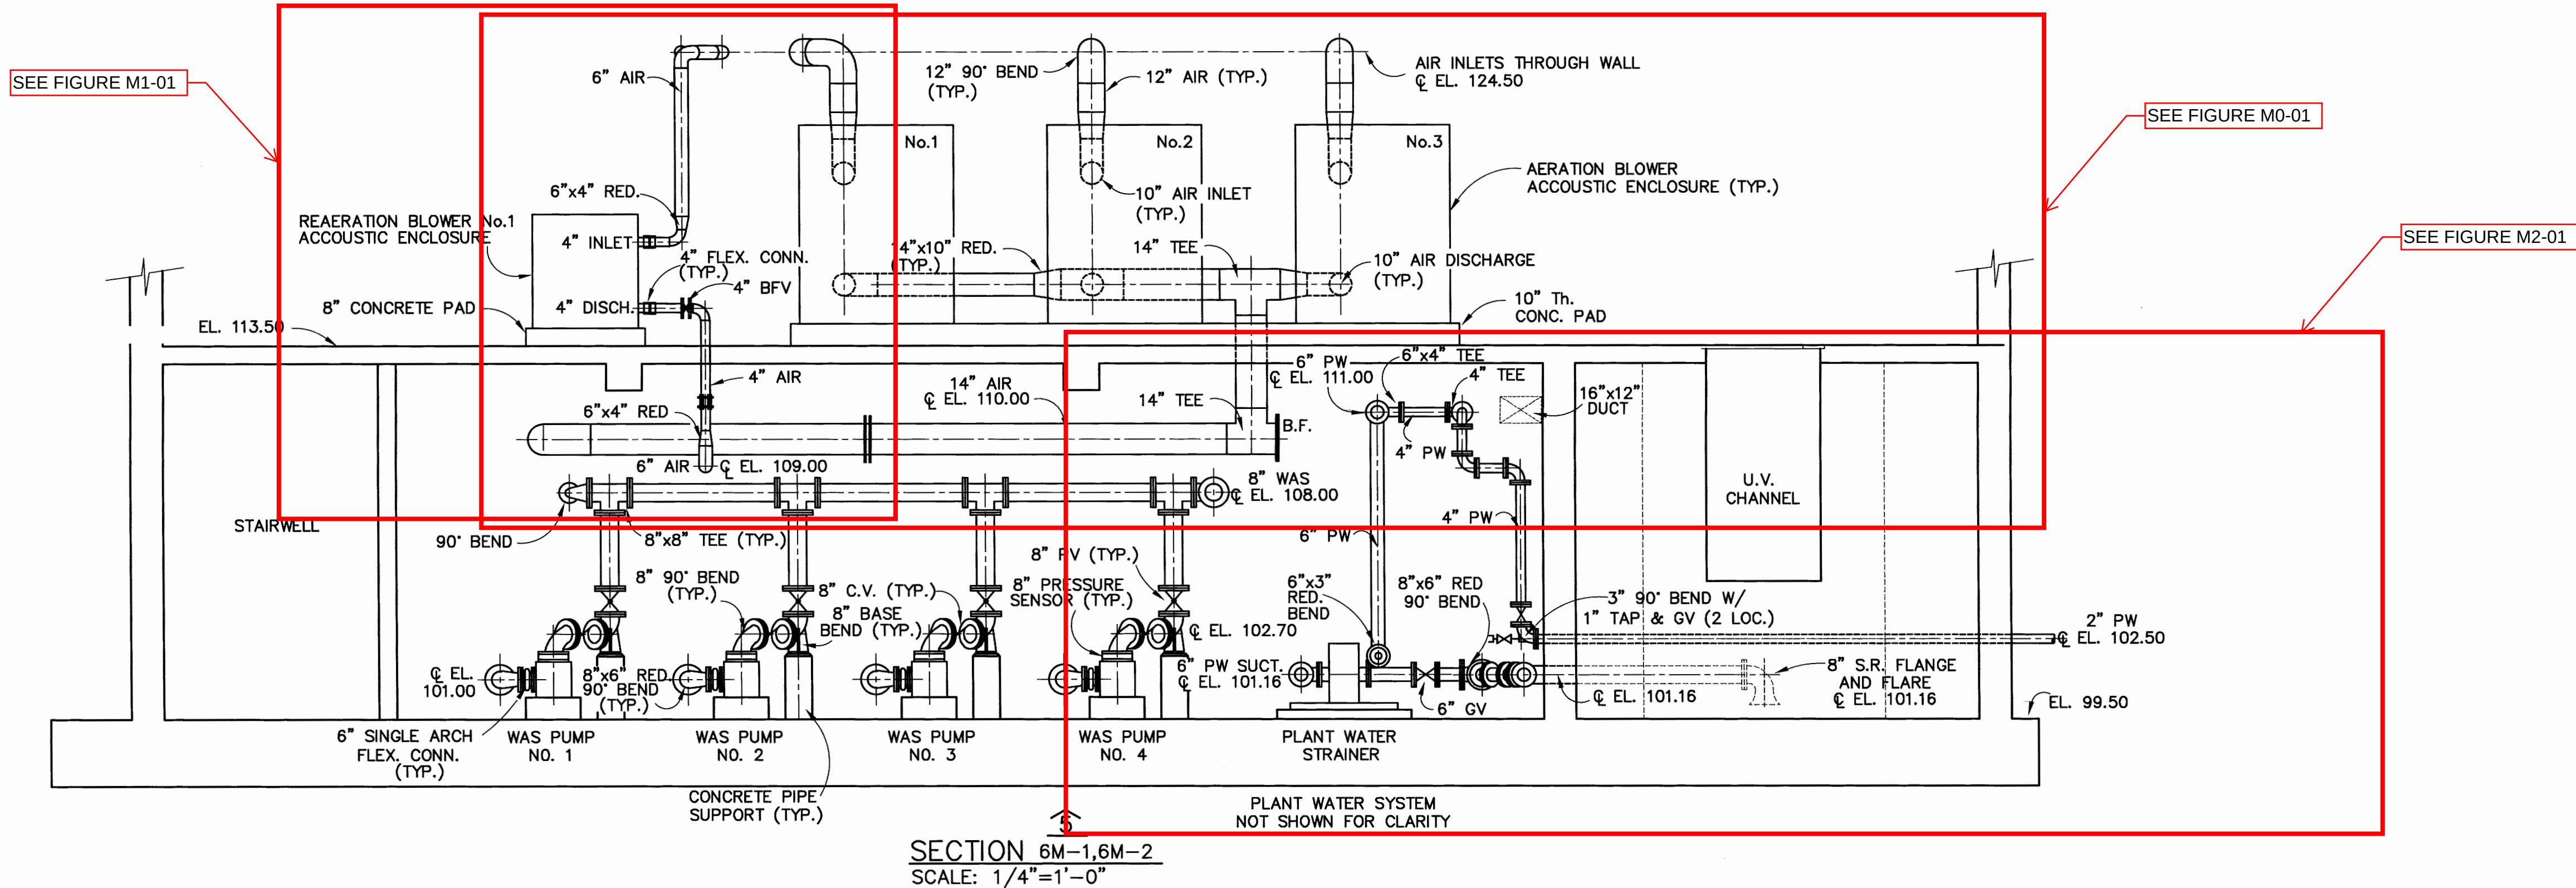

L:\work\36033 CAD\AS-BUILD\MECH\7M-1.dwg, Modd, 01/27/2004, 01:53:50 PM, cdmartin, 148

PLOT DATE 01-14-99 PLOT SCALE 48
FILENAME 216717m1.dwg

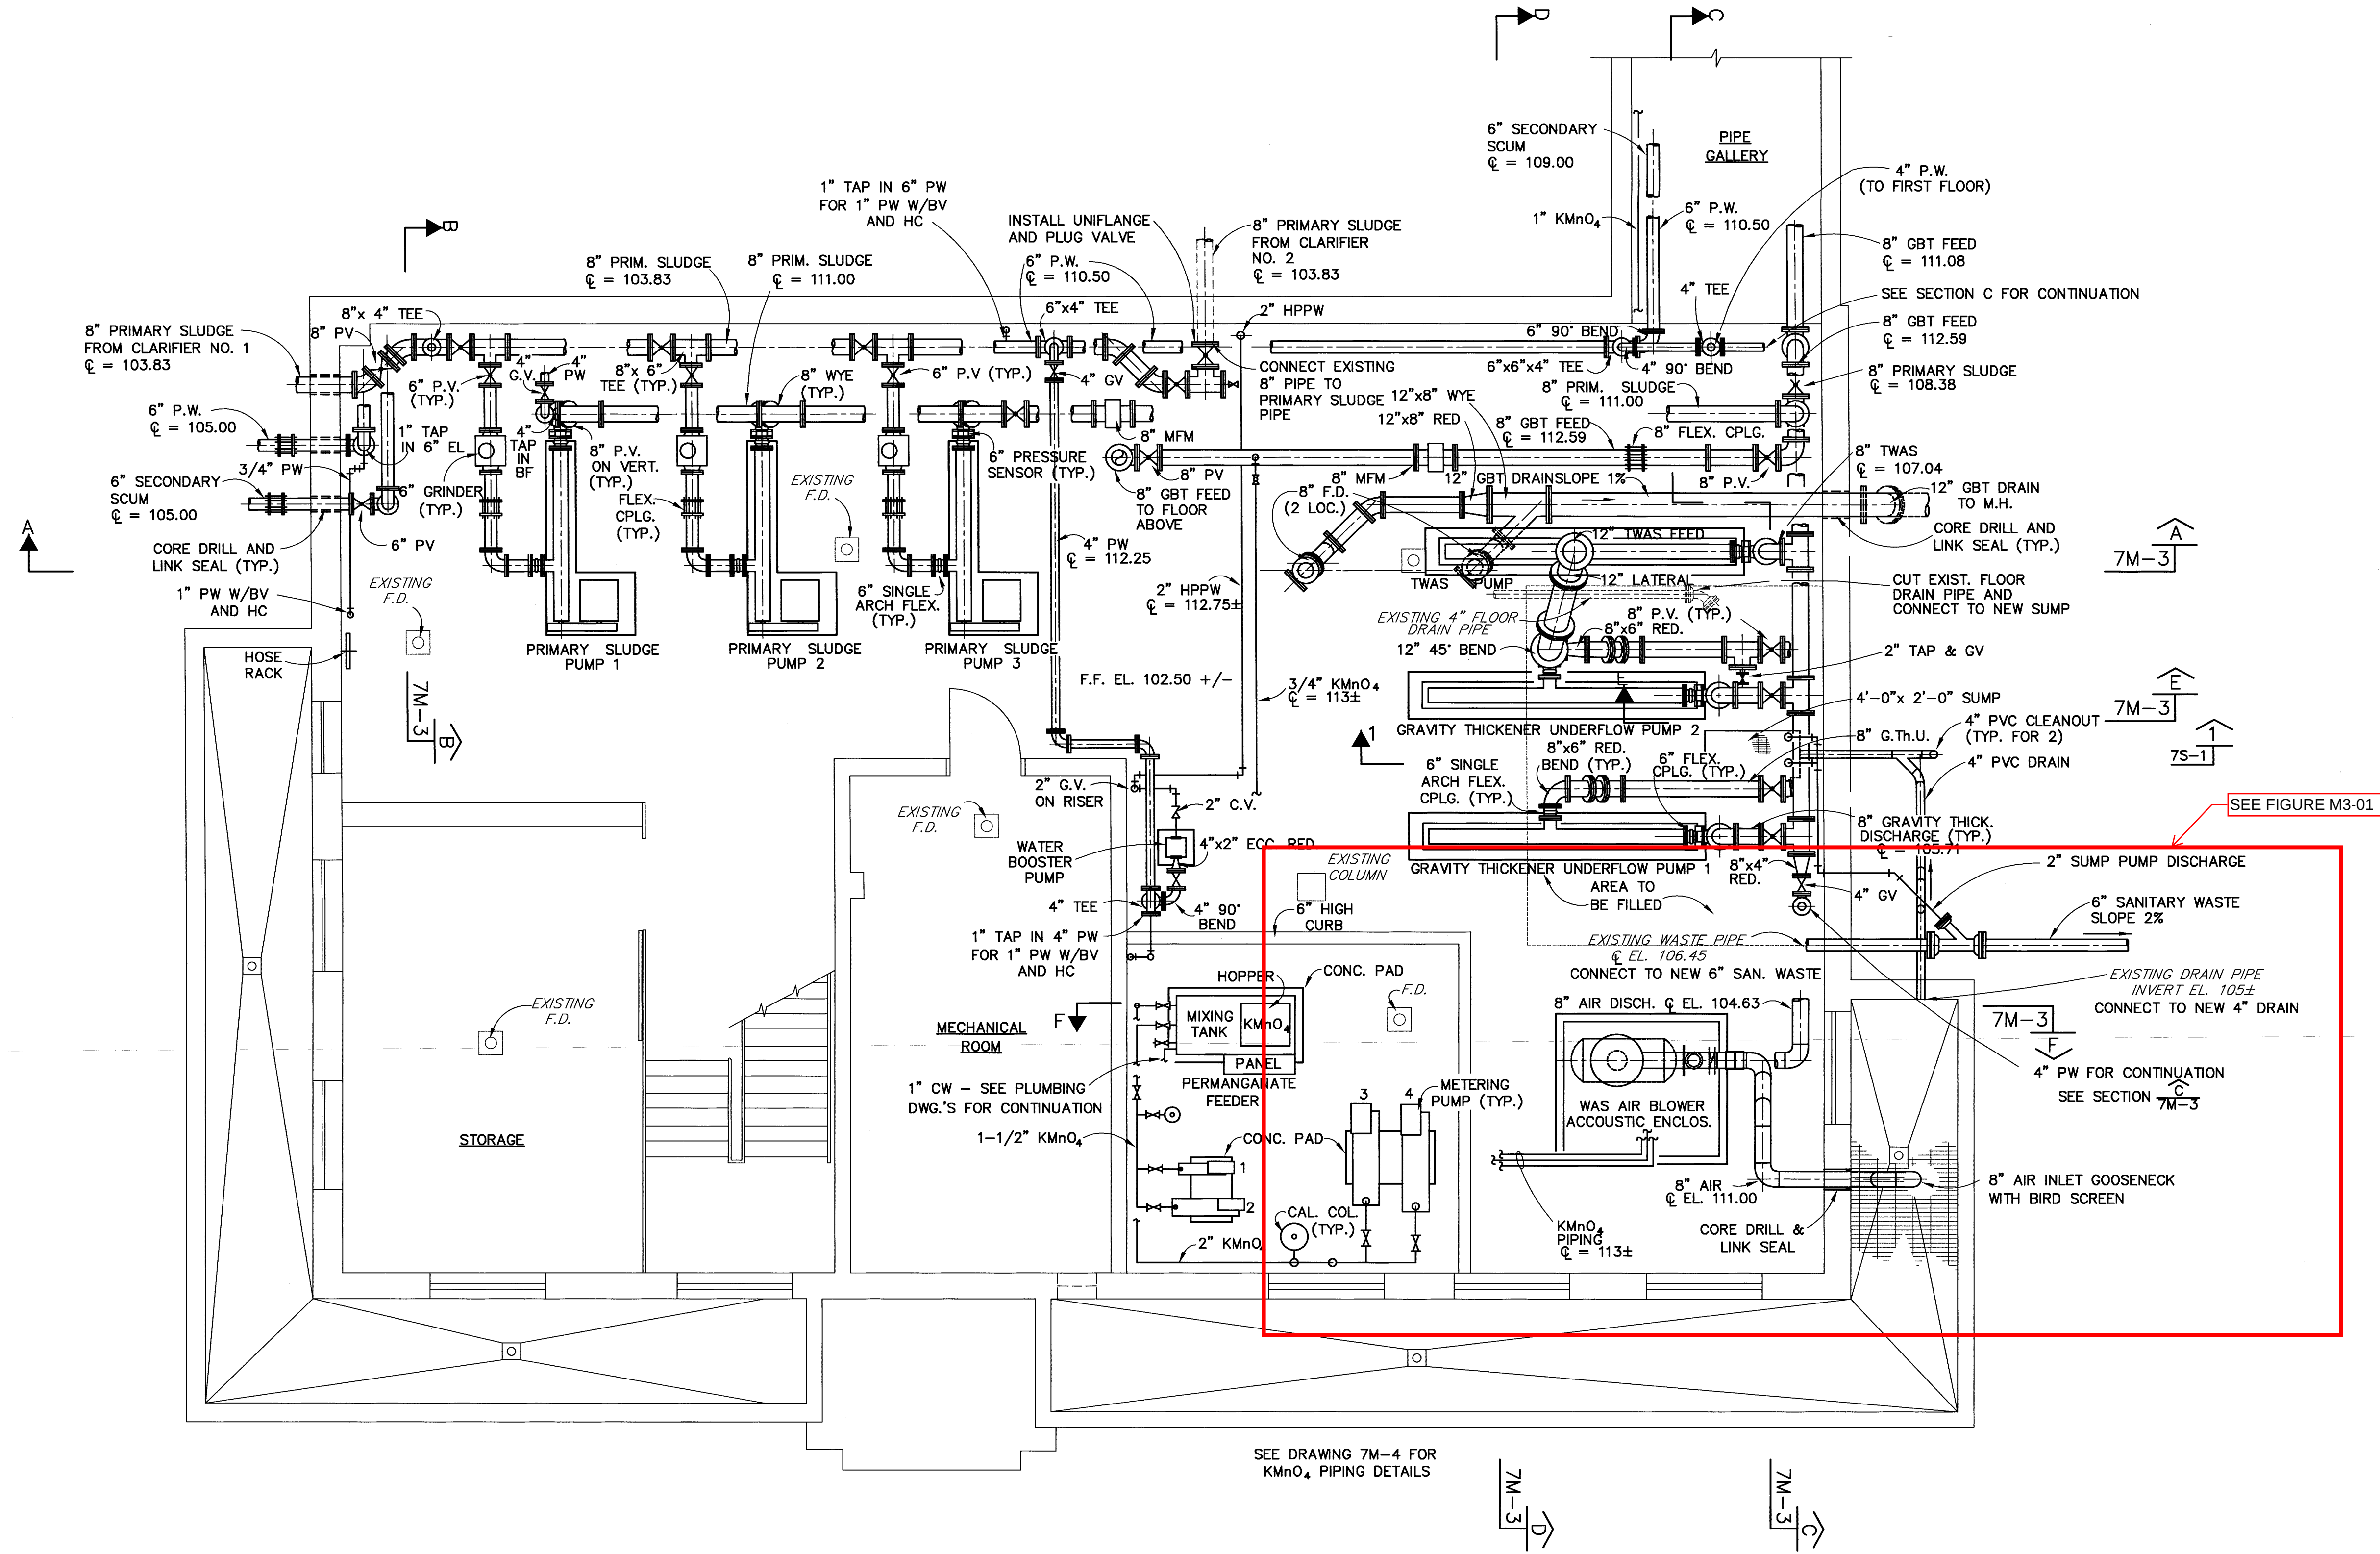

BASEMENT FLOOR PLAN
SCALE: 1/4" = 1'-0"

RECORD PLAN



EARTHTECH

655 Winding Brook Drive Shelton, CT 06483-4337 (860) 857-1200

BRANFORD, CT
WASTEWATER TREATMENT FACILITY
PROCESS BUILDING - BASEMENT PLAN


DESIGNED BY	DWG SCALE
DGS	AS NOTED
DRAWN BY	CONTRACT NO.
F.Pocella	31
CHECKED BY	DATE
KAB	FEB. 1999


7M-1
SHEET 89 OF 169

1	REVISED TO RECORD PLAN	JPR	11/02

BRANFORD, CT
WASTEWATER TREATMENT FACILITY
PROCESS BUILDING – SECTIONS AND SCHEMATIC

DESIGNED BY DGS	DWG SCALE AS NOTED
DRAWN BY JZANIBONI	CONTRACT NO. 31
CHECKED BY KAB	DATE FEB. 1999

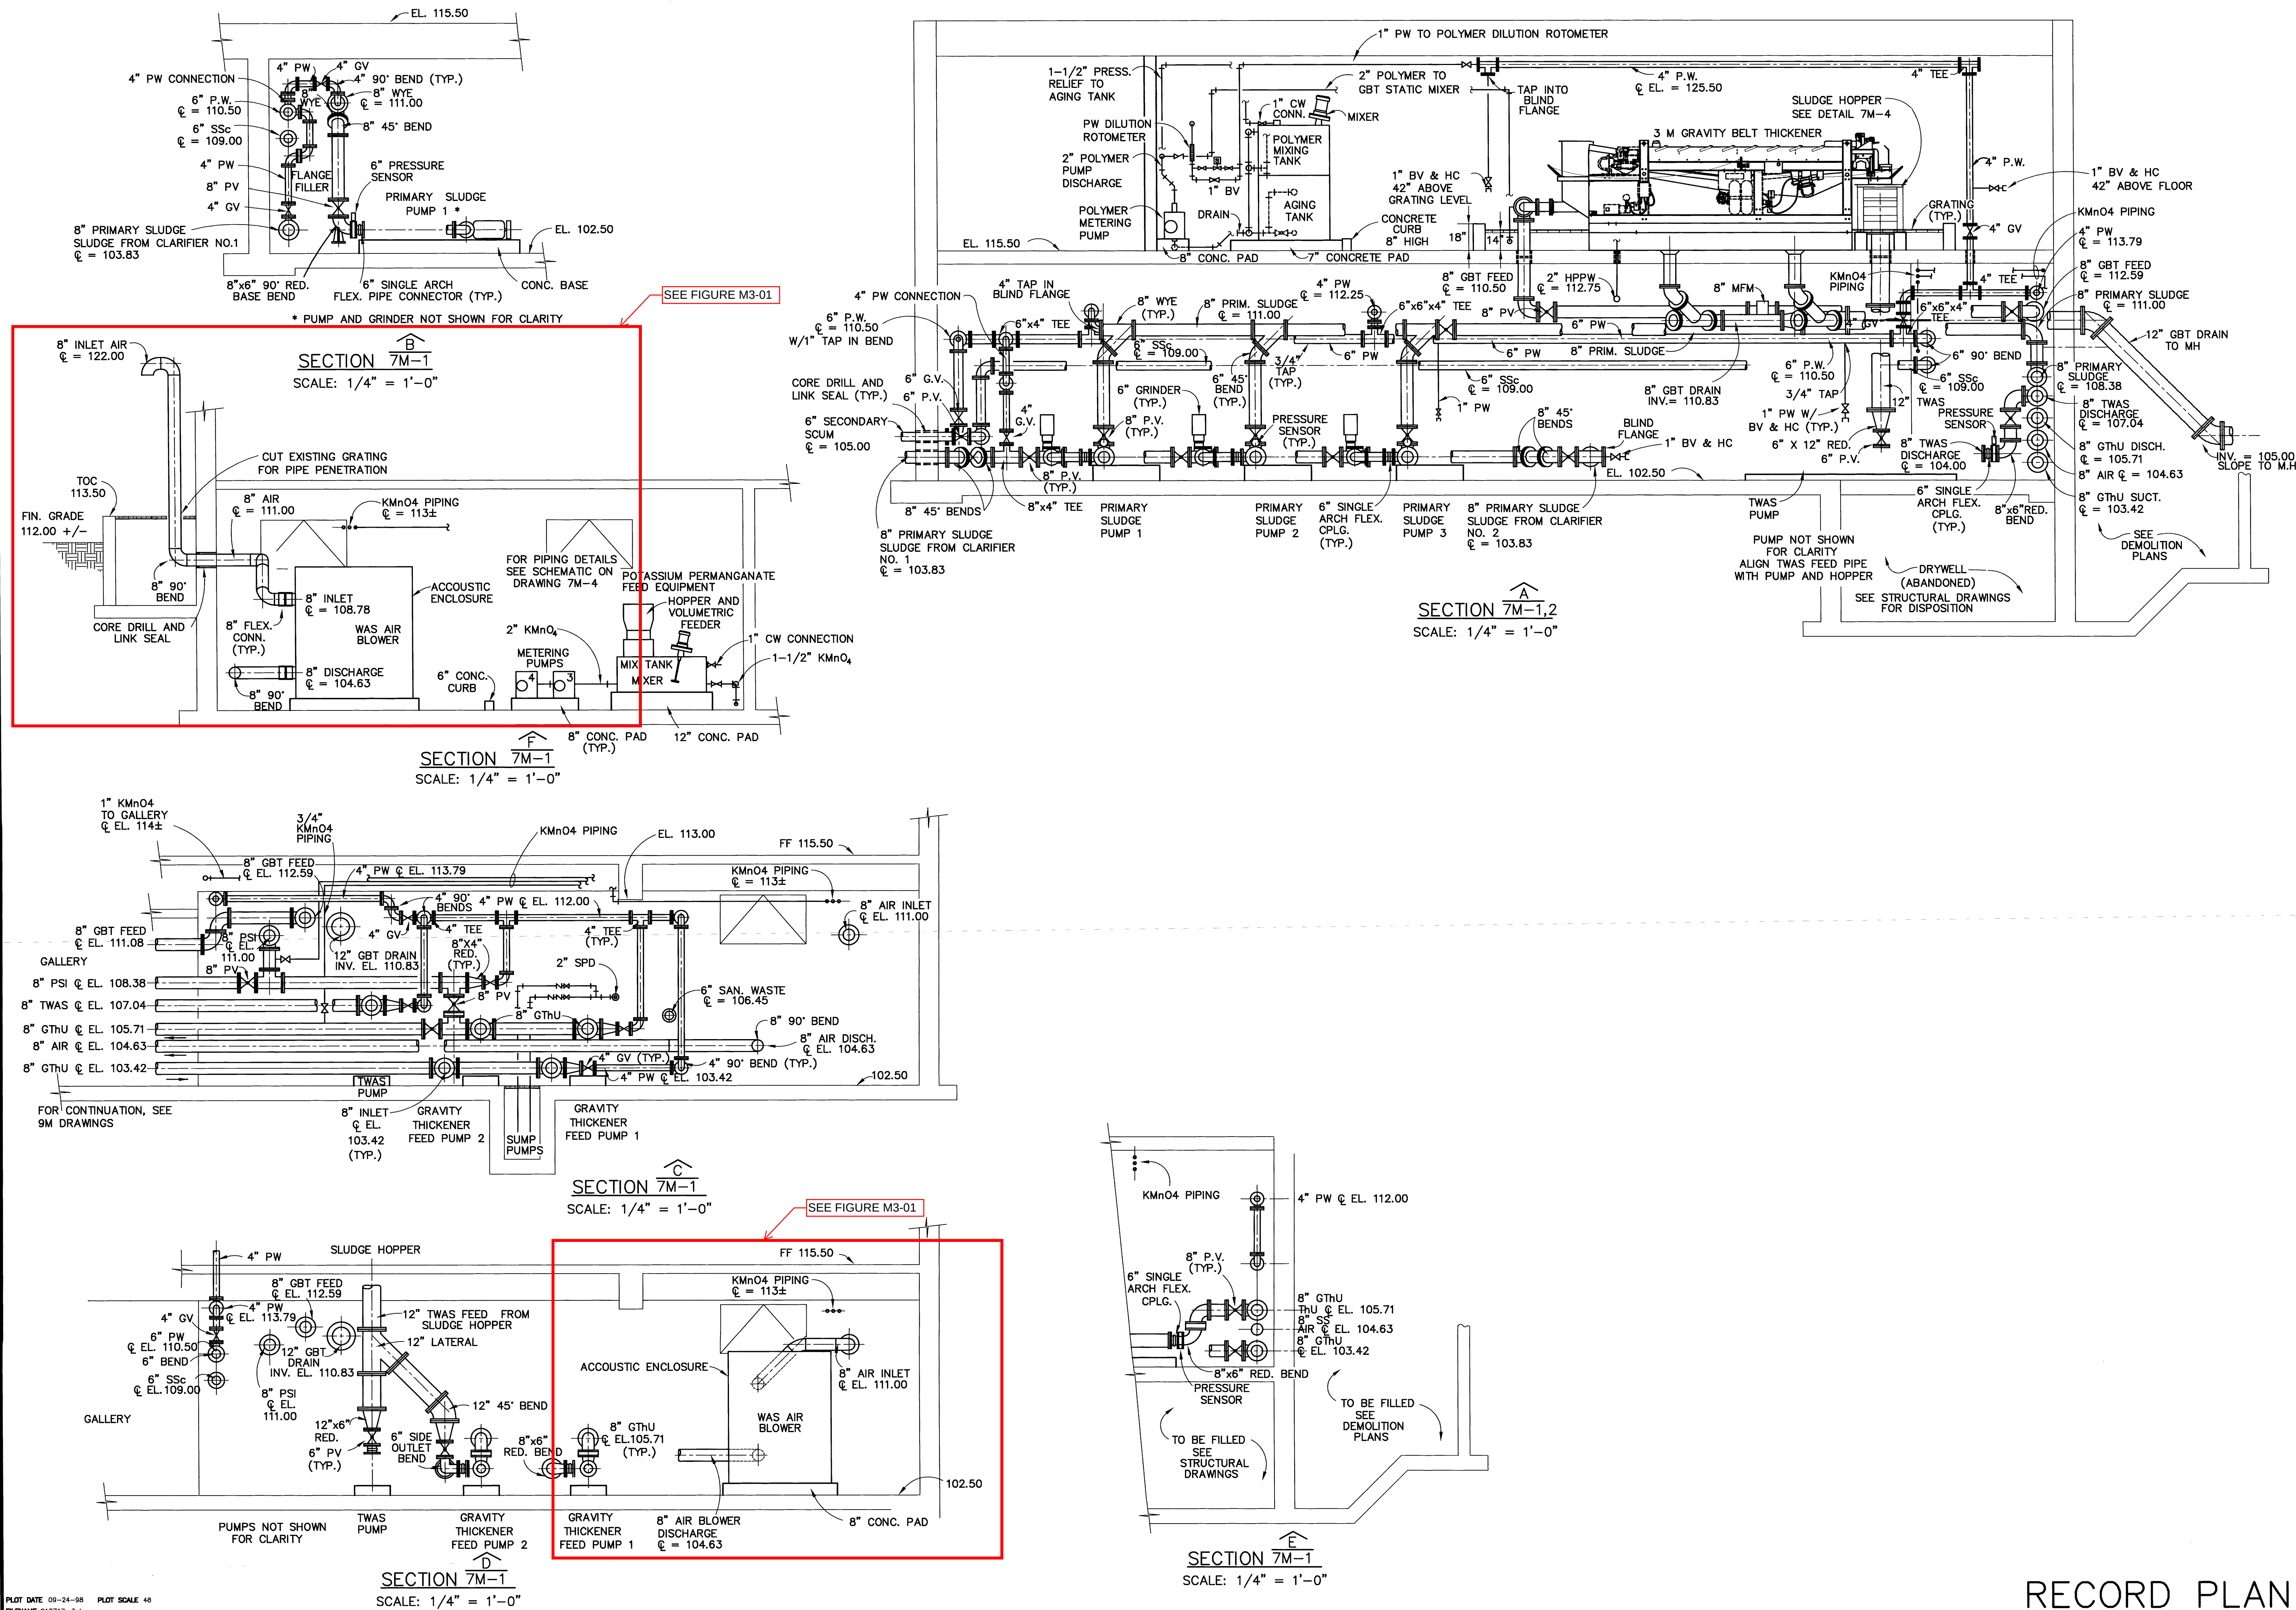

 


RECORD PLAN

NO.	REVISIONS	BY	DATE
1	REVISED TO RECORD PLAN	JPR	11/02

BRANFORD, CT
WASTEWATER TREATMENT FACILITY
SECONDARY PROCESS BUILDING
POWER PLANS—EL.113.50 (FIRST FLOOR) & EL.122.0

DESIGNED BY	DWG SCALE
	1/4"=1'-0"
DRAWN BY	CONTRACT NO.
JZaniboni	31
CHECKED BY	DATE
	FEB. 1999

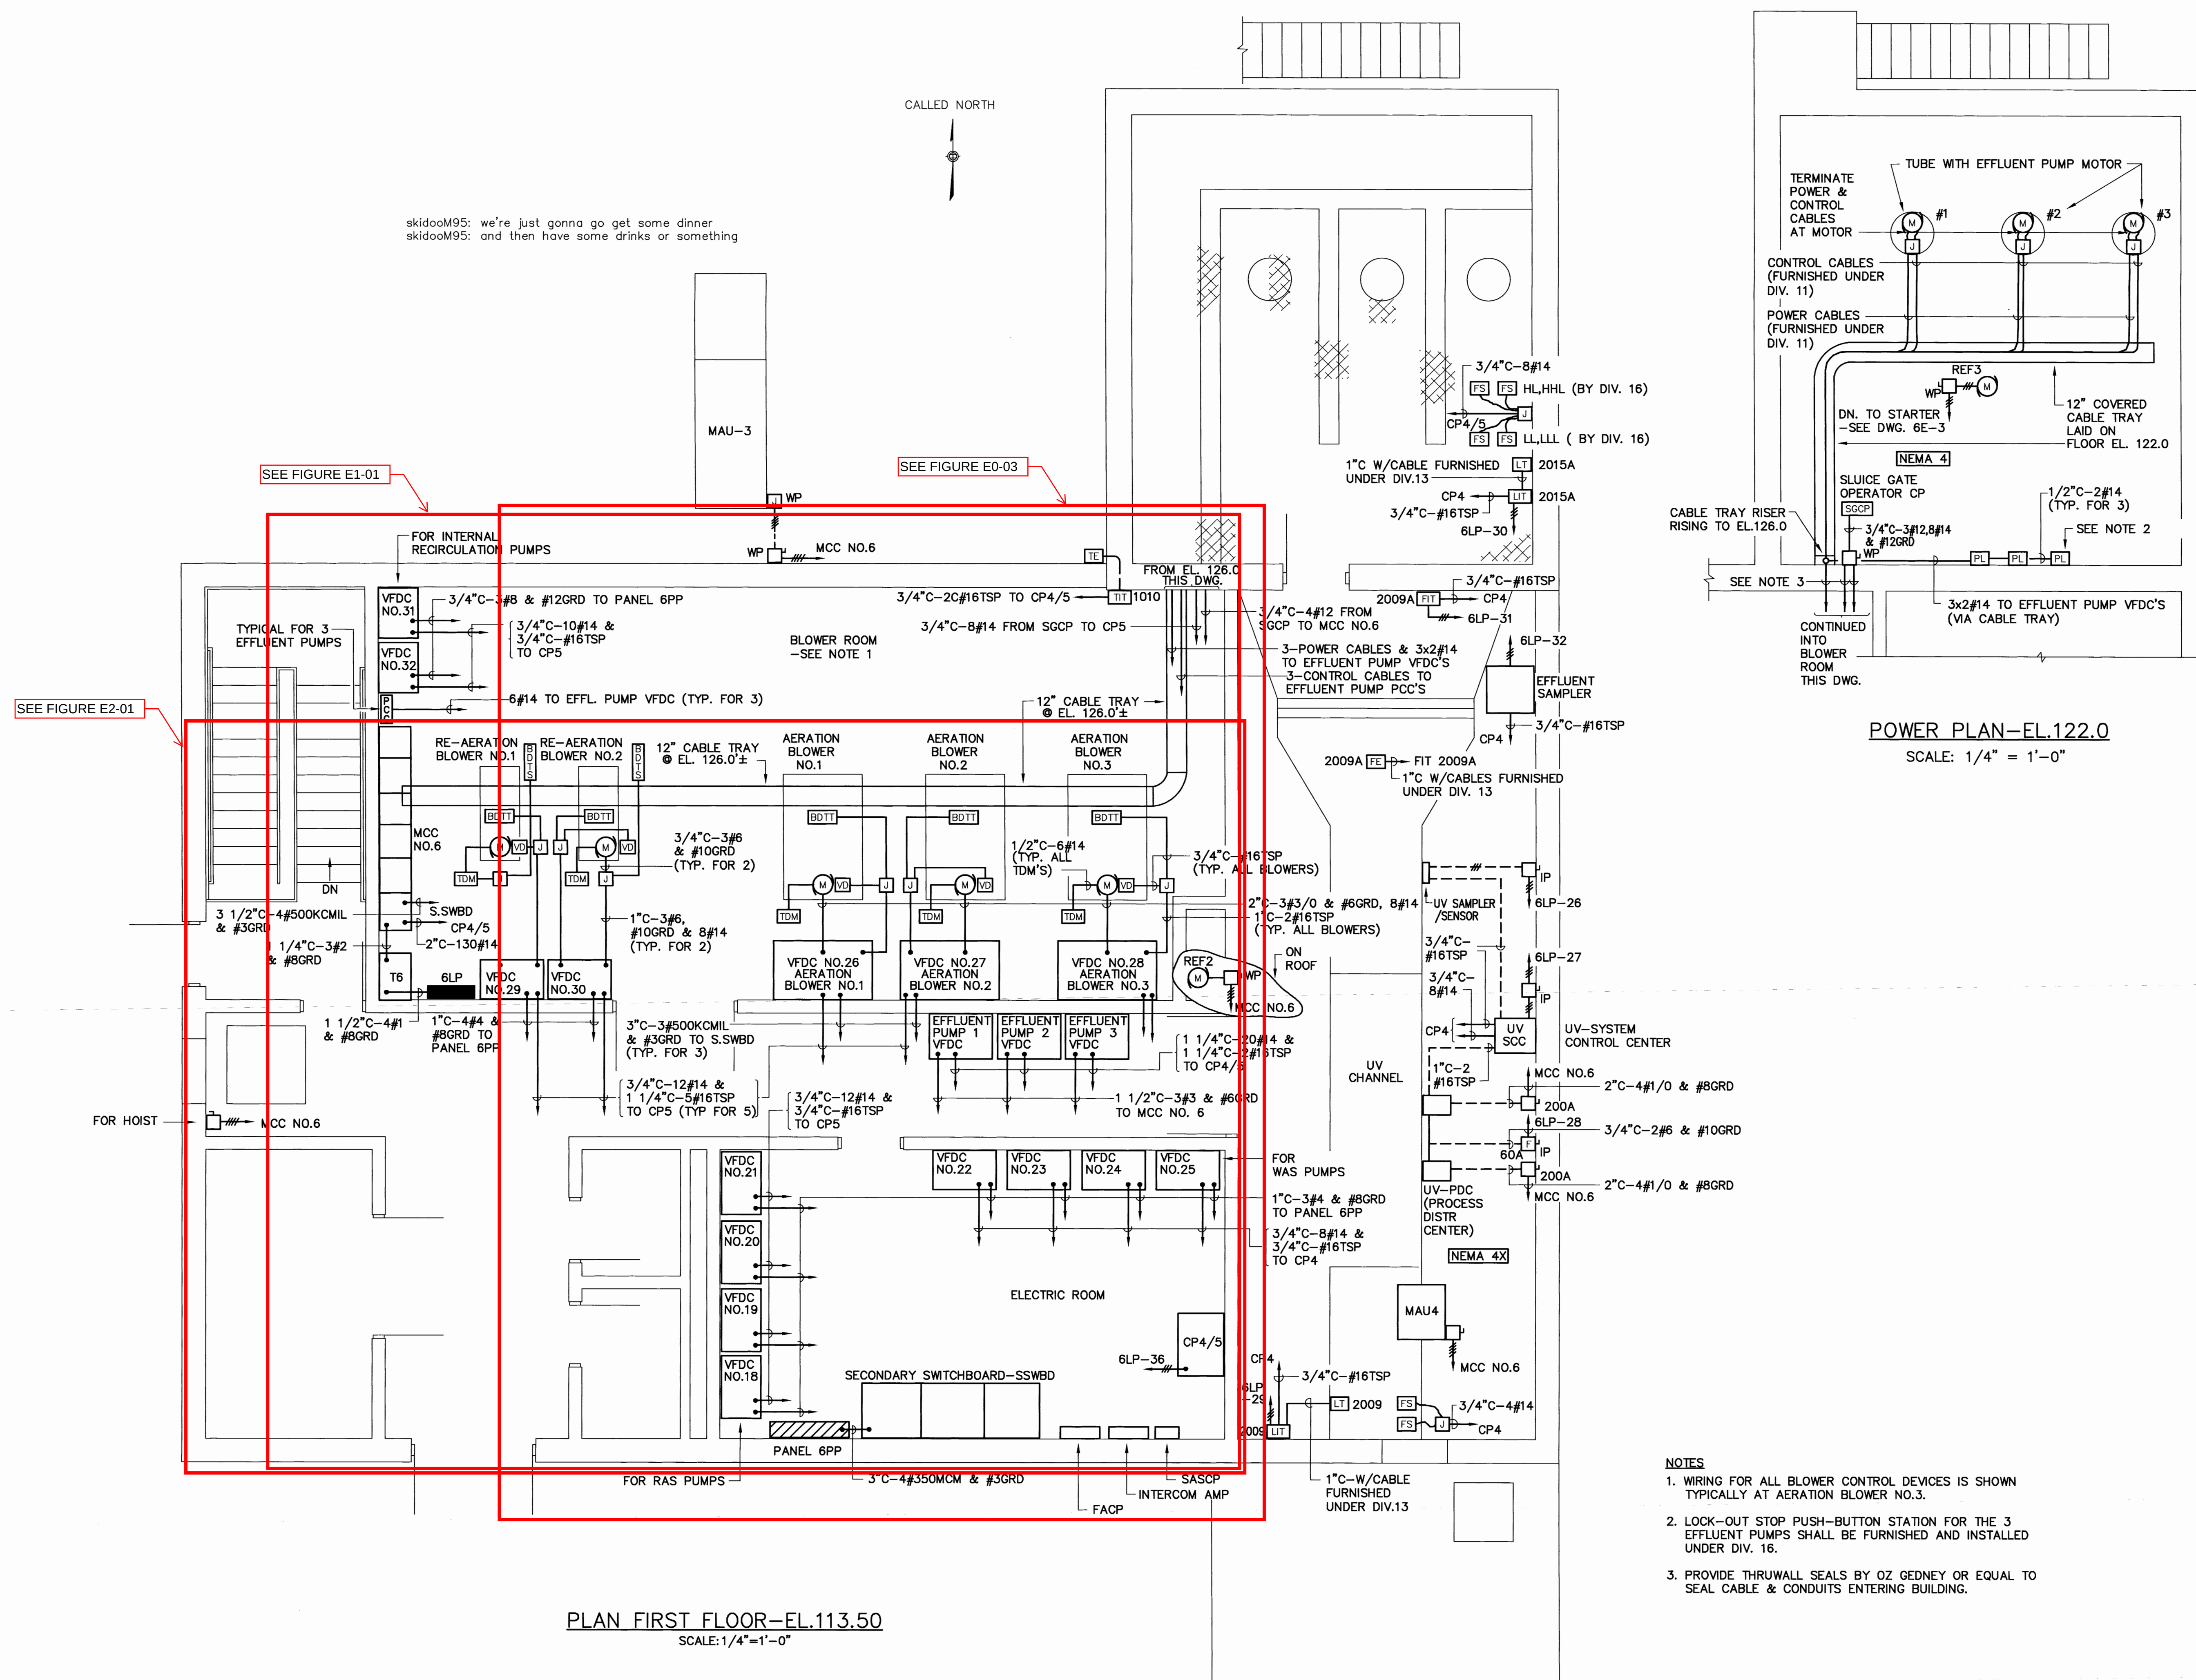

NOTES

1. WIRING FOR ALL BLOWER CONTROL DEVICES IS SHOWN TYPICALLY AT AERATION BLOWER NO.3.
2. LOCK-OUT STOP PUSH-BUTTON STATION FOR THE 3 EFFLUENT PUMPS SHALL BE FURNISHED AND INSTALLED UNDER DIV. 16.
3. PROVIDE THRUWALL SEALS BY OZ GEDNEY OR EQUAL TO SEAL CABLE & CONDUITS ENTERING BUILDING.

PLAN FIRST FLOOR—EL.113.50
SCALE: 1/4"=1'-0"

RECORD PLAN

[illegible]

BRANFORD, CT


WASTEWATER TREATMENT FACILITY

SECONDARY PROCESS BUILDING
BASEMENT POWER PLAN

DESIGNED BY	DWG SCALE 1/4" = 1'-0"
DRAWN BY JZaniboni	CONTRACT NO 31
CHECKED BY	DATE FEB. 1999

6E-2

SHEET 161 OF 169

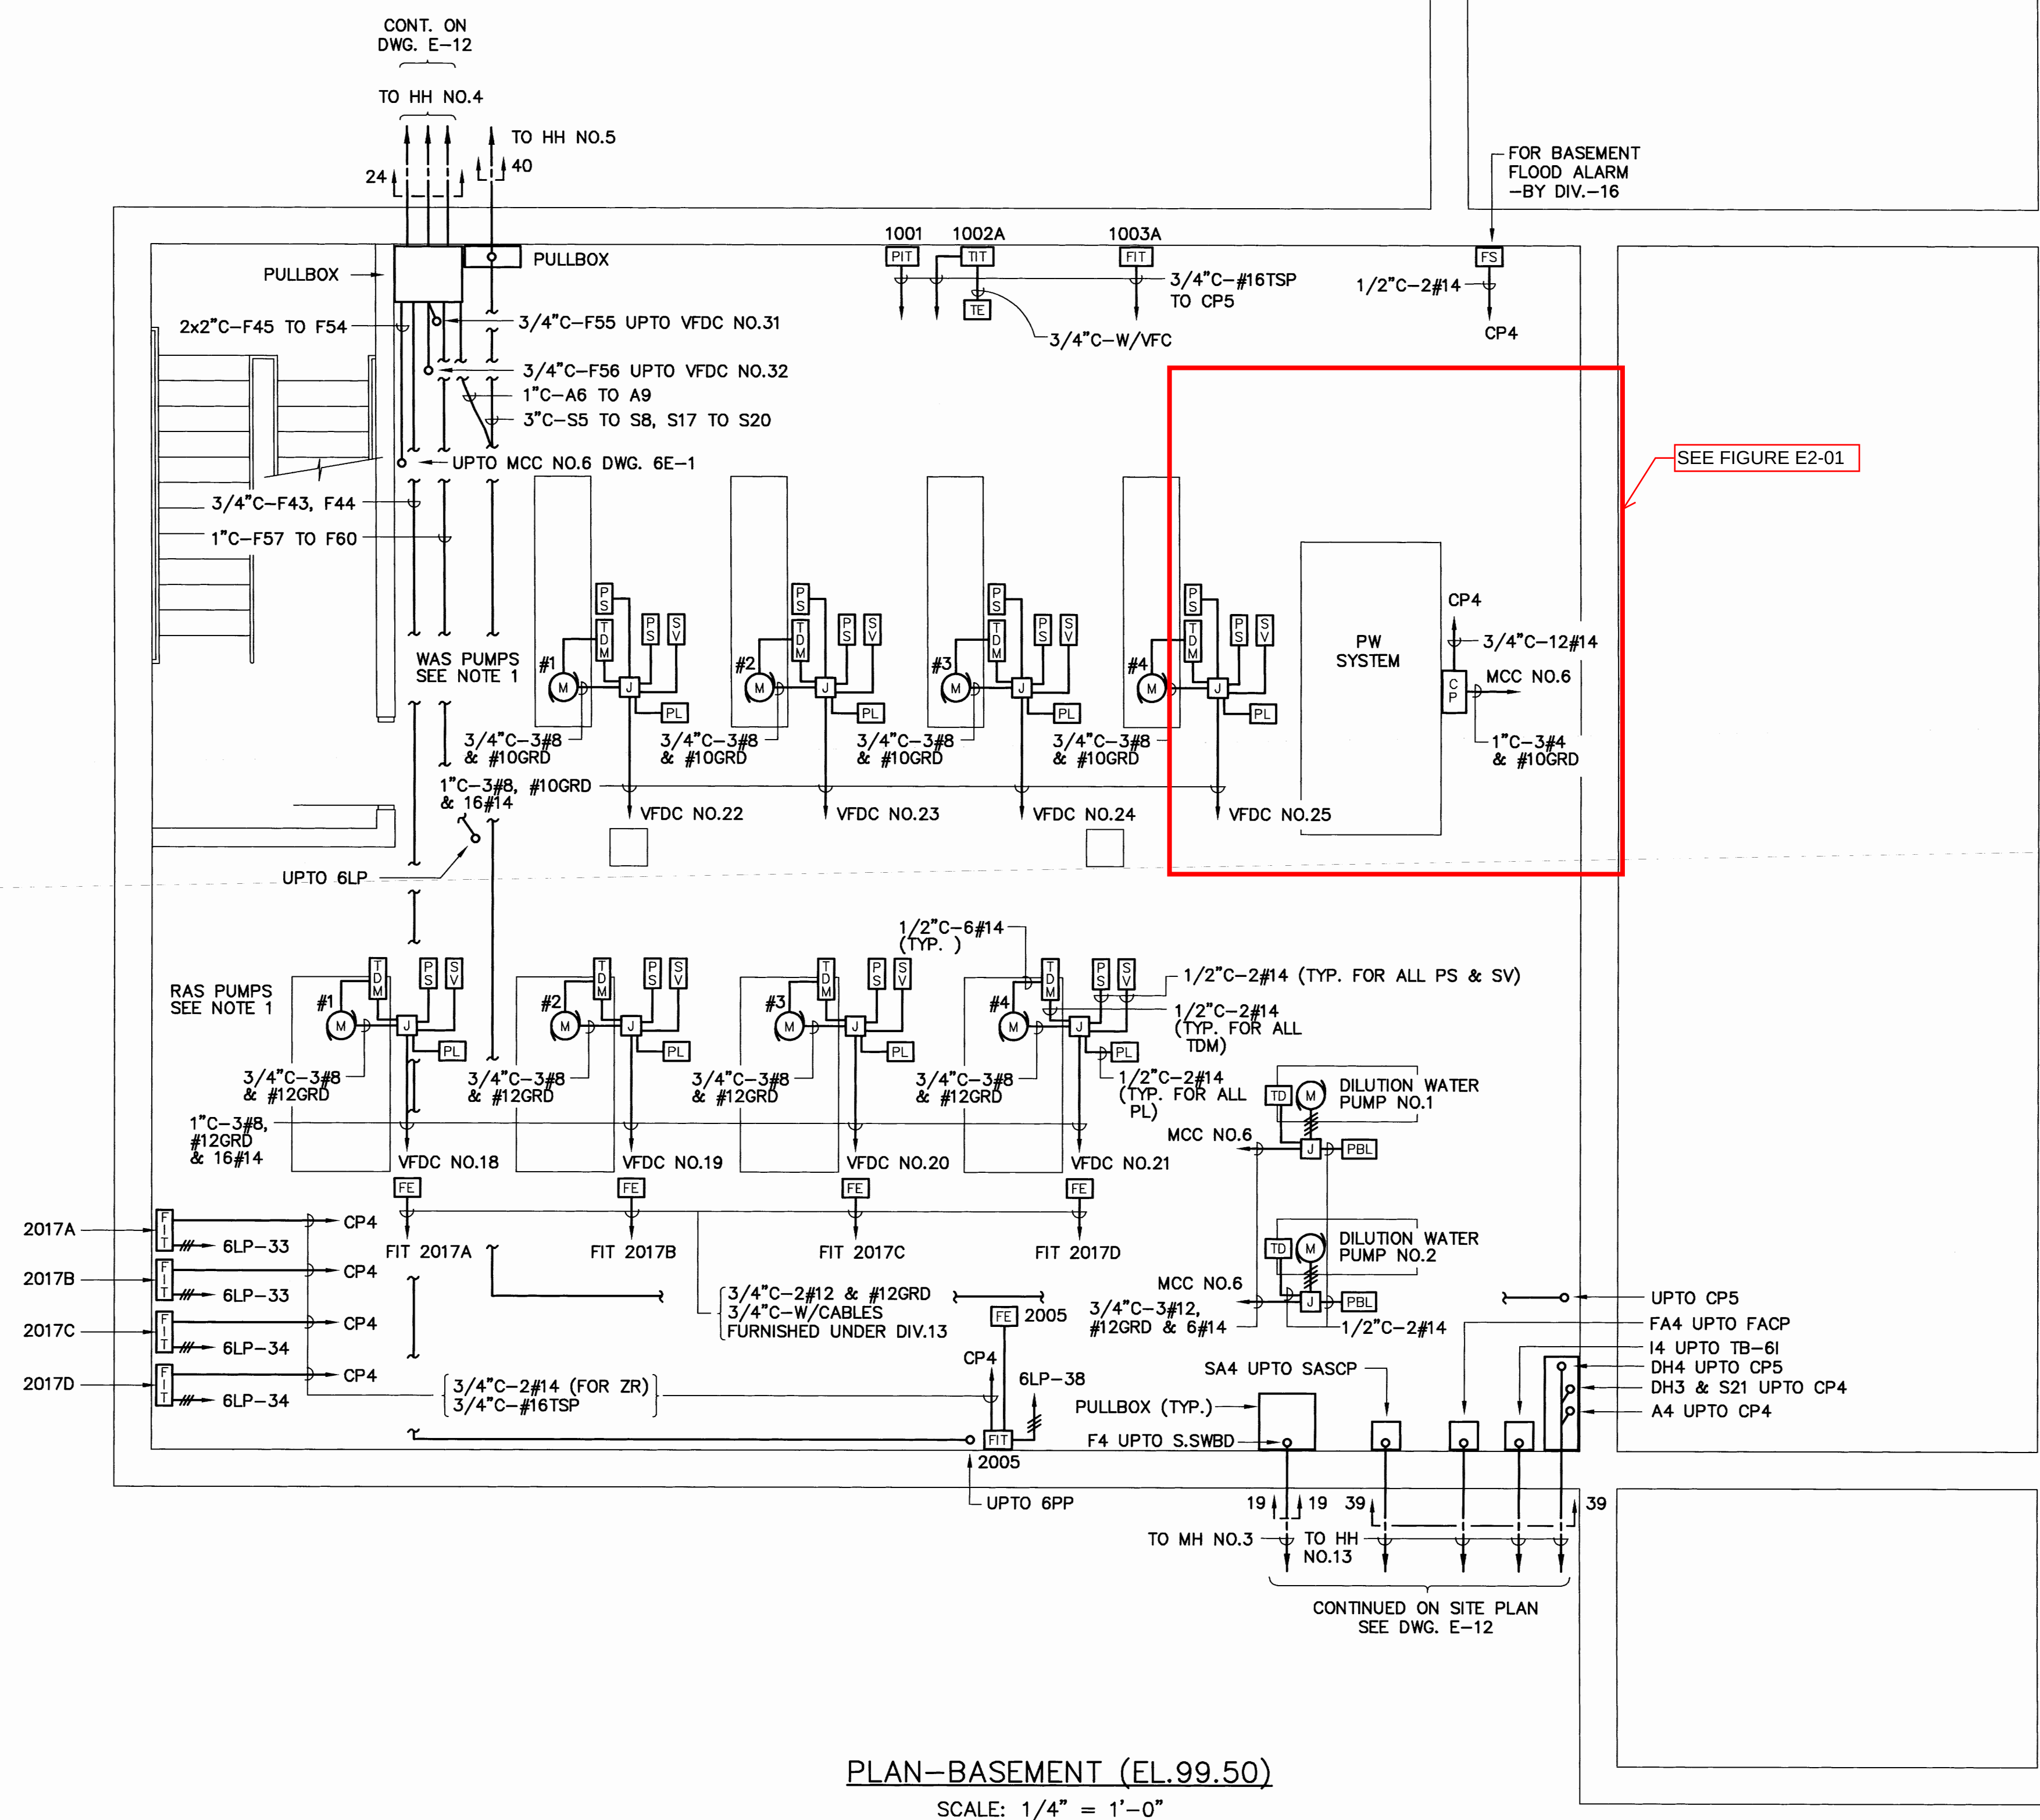

NOTES


1. WIRING FOR ALL WAS & RAS PUMPS CONTROL DEVICES IS SHOWN TYPICALLY AT RAS PUMP NO.4.
2. FOR UG DUCTBANK SECTIONS, SEE DWG NO. E-13.

RECORD PLAN

L:\proj\38603\CAD\AS BUILTS\ELECTRICAL\VEI.dwg, Model, 02/02/2004, 08:27:19 AM, cdpmmartin, 1:1

PLOT DATE 05-05-99 PLOT SCALE 1
FILENAME 218717e1.dwg

SEE FIGURE E3-01

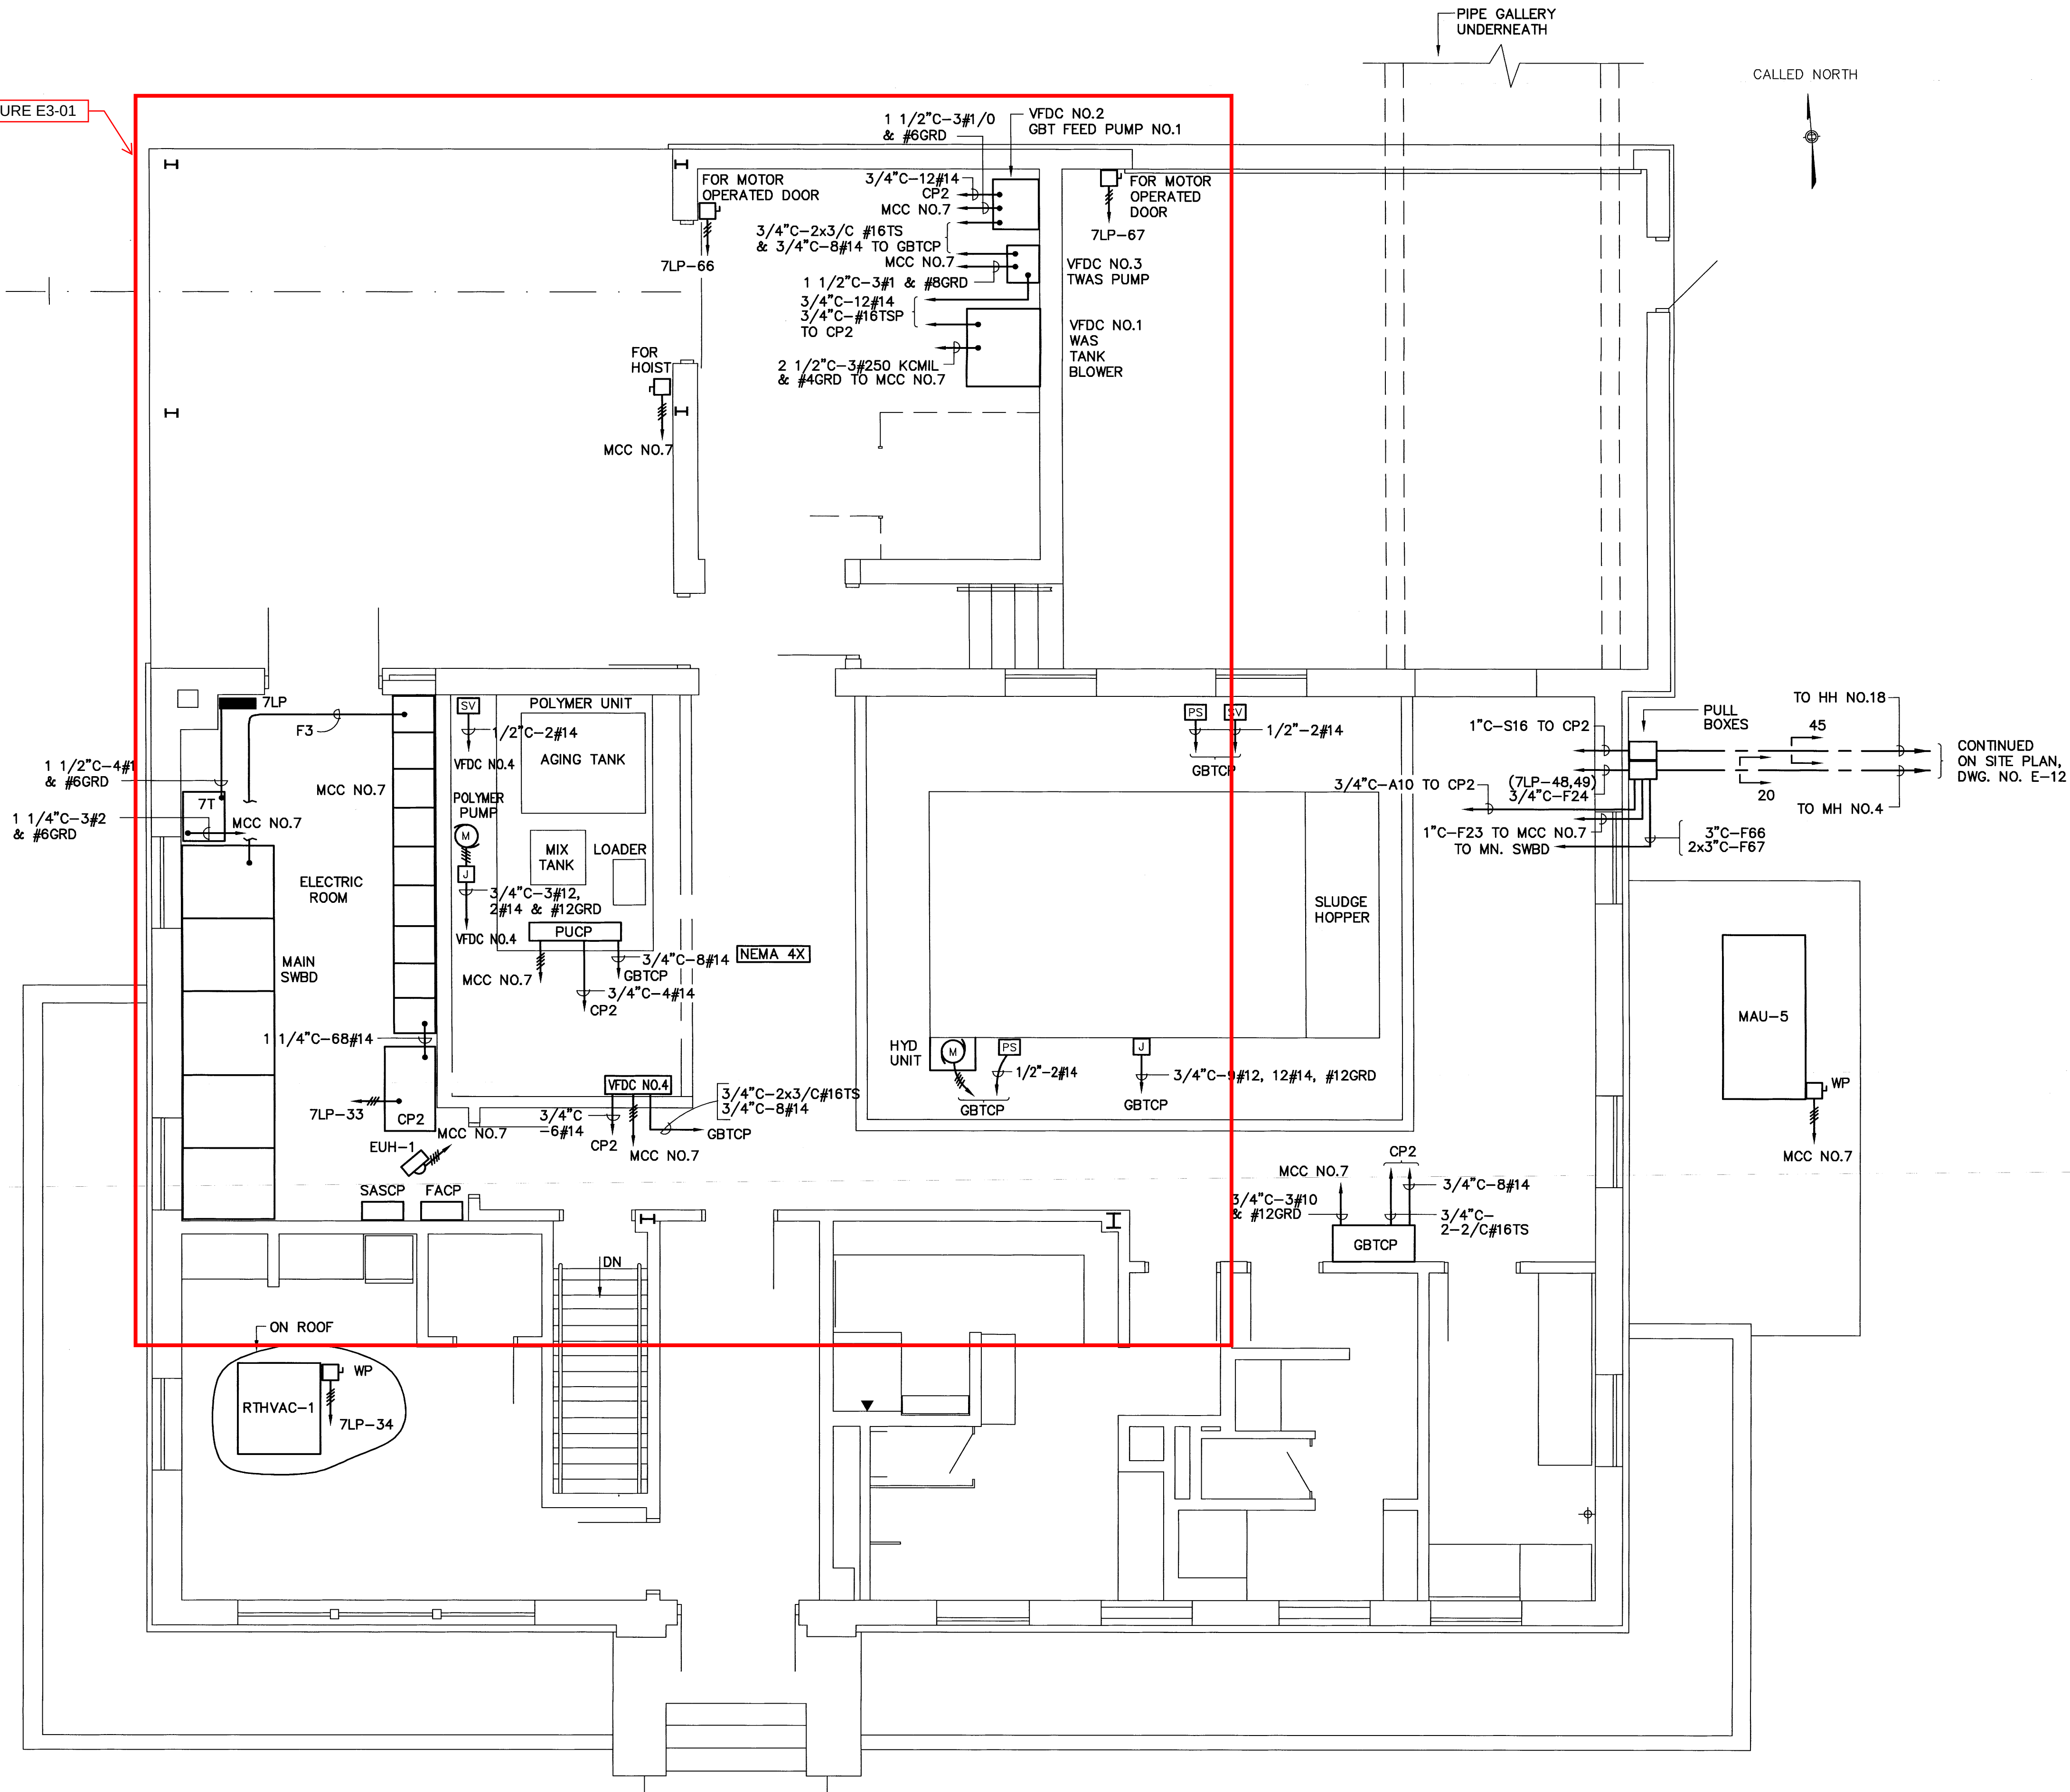

FIRST FLOOR POWER PLAN (EL.115.50)
SCALE: 1/4" = 1'-0"

RECORD PLAN

7E-1


SHEET 1640F169

BRANFORD, CT
WASTEWATER TREATMENT FACILITY
SOLIDS PROCESSING BUILDING
FIRST FLOOR POWER PLAN

DESIGNED BY	DWG SCALE
DRAWN BY	1/4" = 1'-0"
CHECKED BY	CONTRACT NO
	31
	DATE
	FEB. 1999

NO.	1	REVISED TO RECORD PLAN	REVISIONS
BY	JPR	DATE	11/02

EARTHTECH
655 Whiting Brook Drive
Danbury, CT 06833-4337 (860) 857-1200

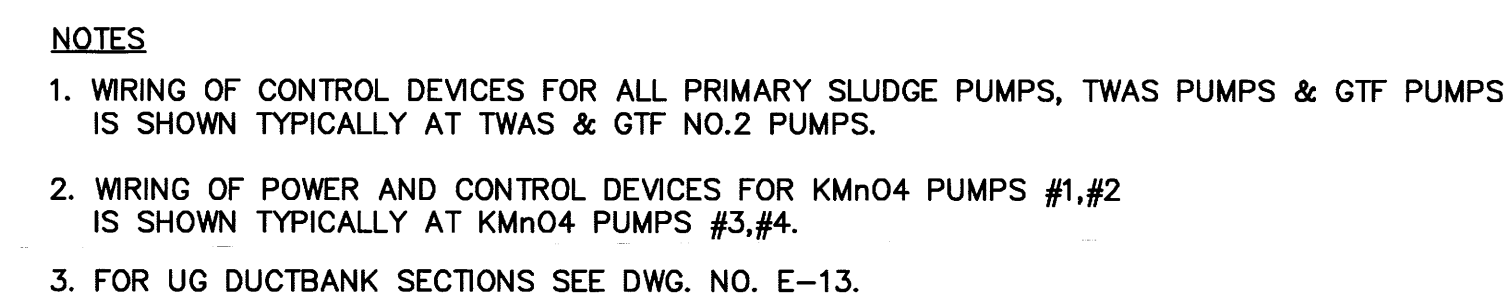

RECORD PLAN